

A
B
C
D
E
F
G

- E

D

C

B

A


Space	Function of Space	Occupant Load Factor	Area (SF)	Occupant Load
Open Area	Business	150	736	5
Control Room	Business	150	299	2
Total				7

NO
=C
(16)

NOTE: ILLINOIS OVERLOOK A MIRROR IMAGE OF MISSOURI OVERLOOK FOR EGRESS

$$1/16'' = 1'-0''$$

EGRESS POINTS - MISSOURI OVERLOOK
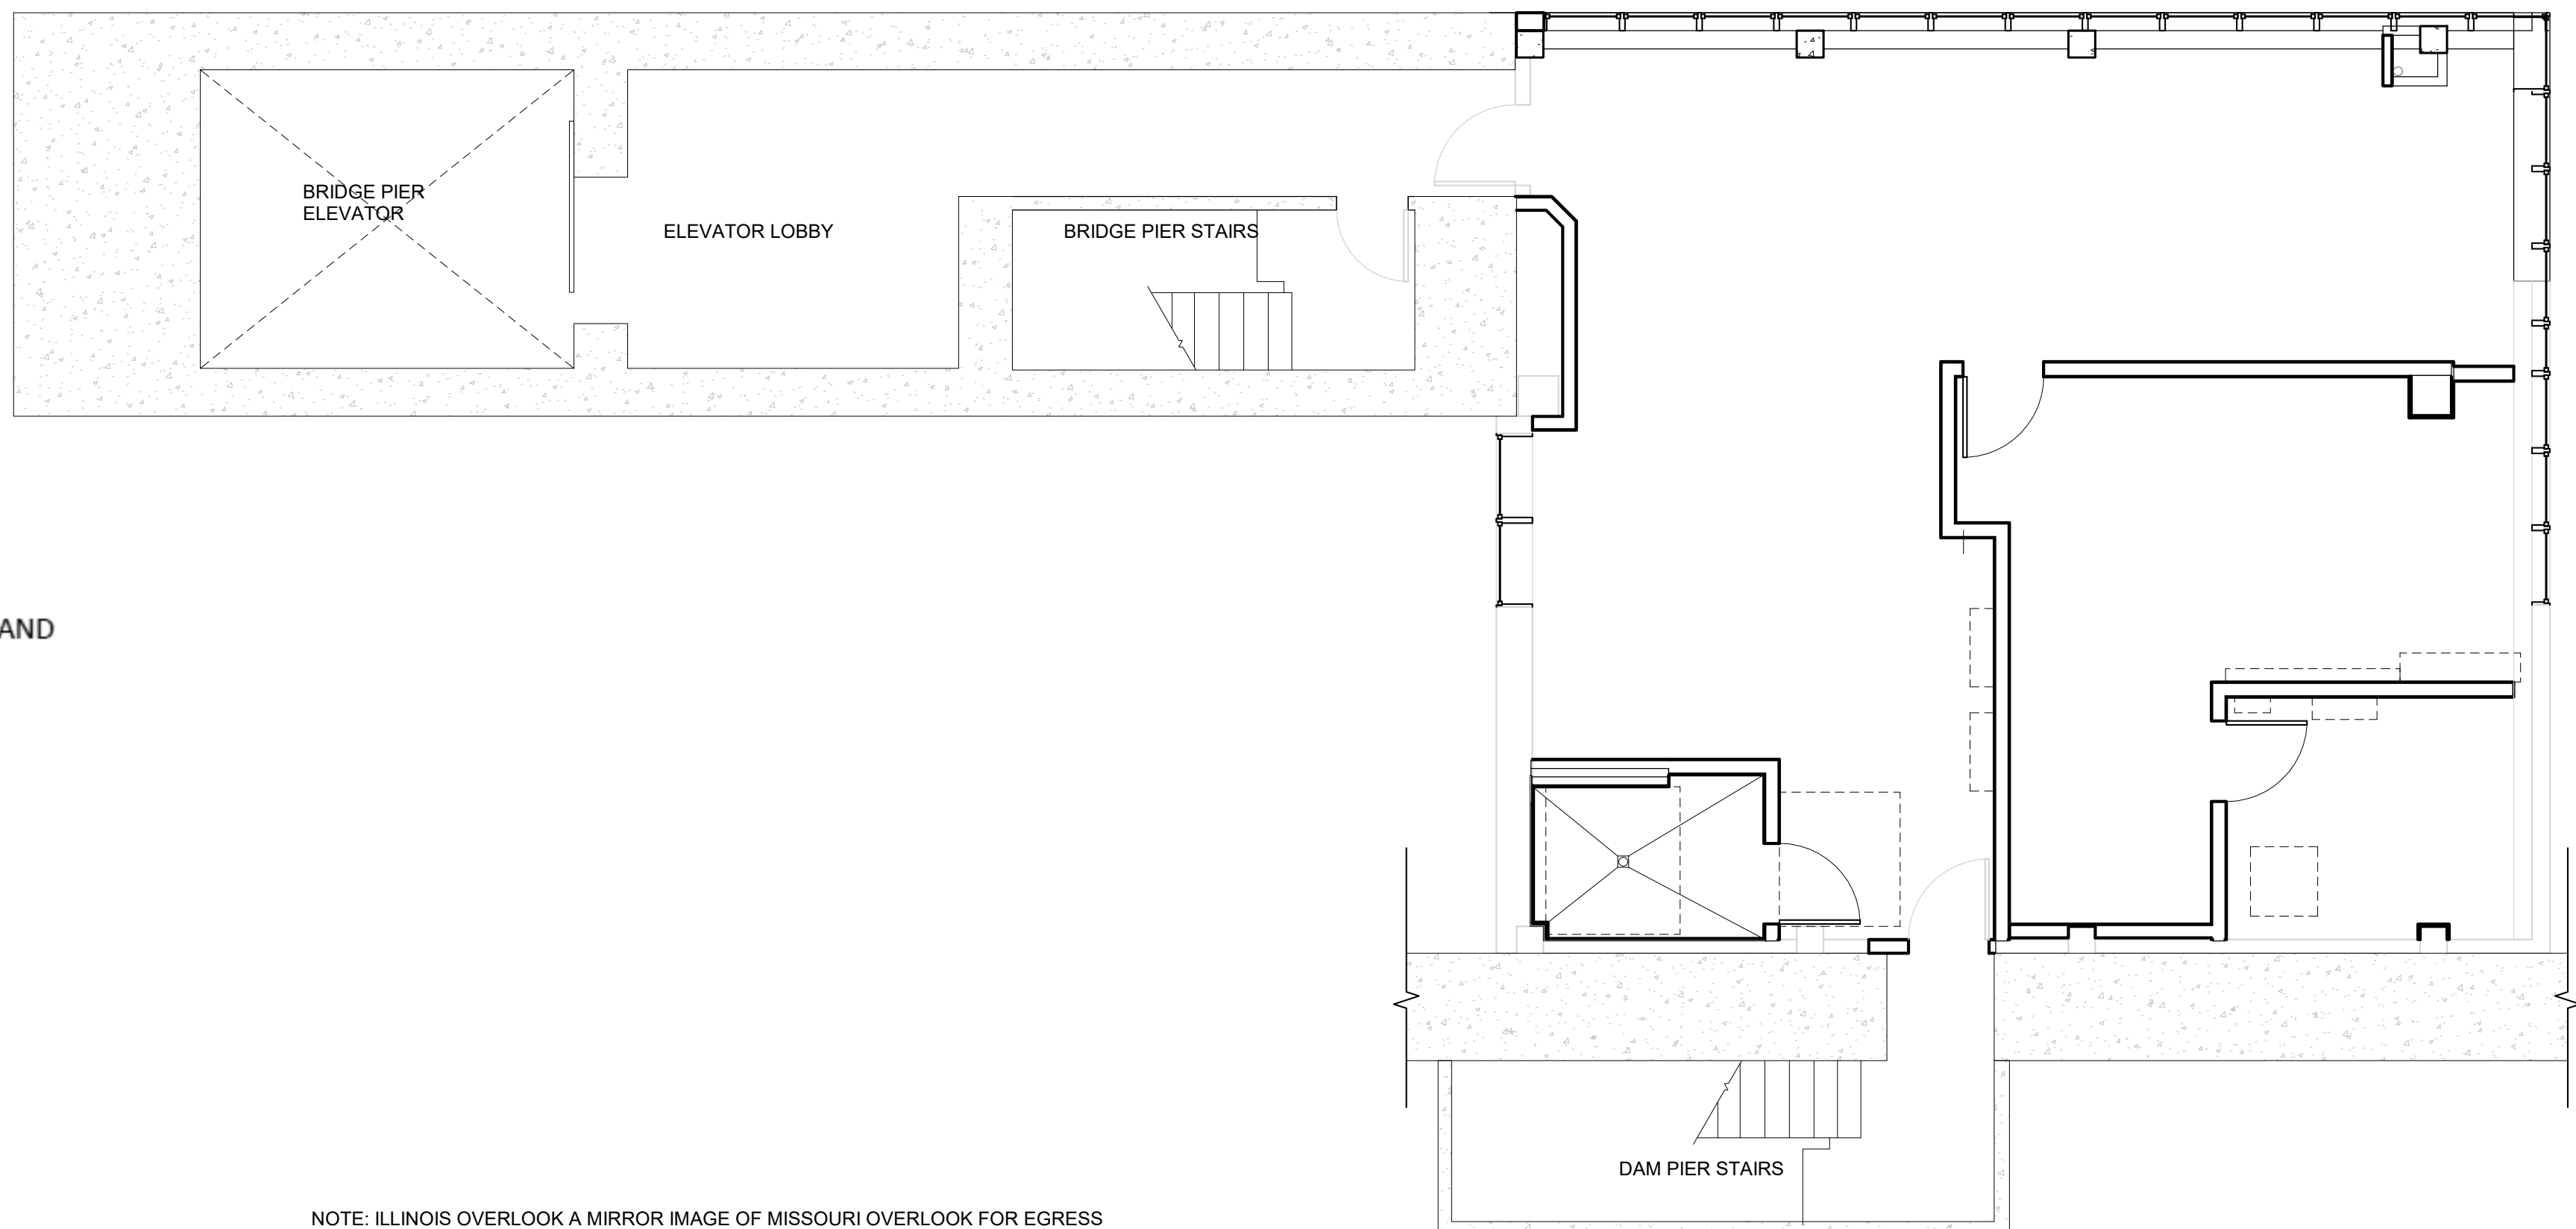
$$1/16'' = 1'-0''$$
$$1/16'' = 1'-0''$$
$$1/16'' = 1'-0''$$
$$1/16'' = 1'-0''$$
$$1/16'' = 1'-0''$$
$$1/16'' = 1'-0''$$


NOTE: ILLINOIS OVERLOOK A MIRROR IMAGE OF MISSOURI OVERLOOK FOR EGRESS

$$1/16'' = 1'-0''$$
[illegible]

US ARMY CORPS OF ENGINEERS ST. LOUIS DISTRICT ST. LOUIS, MISSOURI 63103	MY	MAY 2021
	DRAWN BY:	
	SOLICITATION NO.:	MS22P52-R-0011
	CHECKED BY:	FA
	SUBMITTED BY:	
	SMH	
	SIZE	
	ANSI D	

MAIN LOCK OVERLOOK ALTERATIONS
ALTON, ILLINOIS
MISSISSIPPI RIVER

SHEET ID

AE100



[illegible]

US ARMY CORPS OF ENGINEERS ST. LOUIS DISTRICT ST. LOUIS, MISSOURI 63103	DESIGNED BY: MY	DATE: MAY 2021
	DRAWN BY: MY	SOLICITATION NO.: W912P9-2-R-0011
	CHECKED BY: FA	CONTRACT NO.:
	SUBMITTED BY:	
	DATE SUBMITTED: SPEC.	
	ANSI D	

ILLINOIS AND MISSOURI OVERLOOK DEMOLITION
PLANS


SHEET ID

AD101

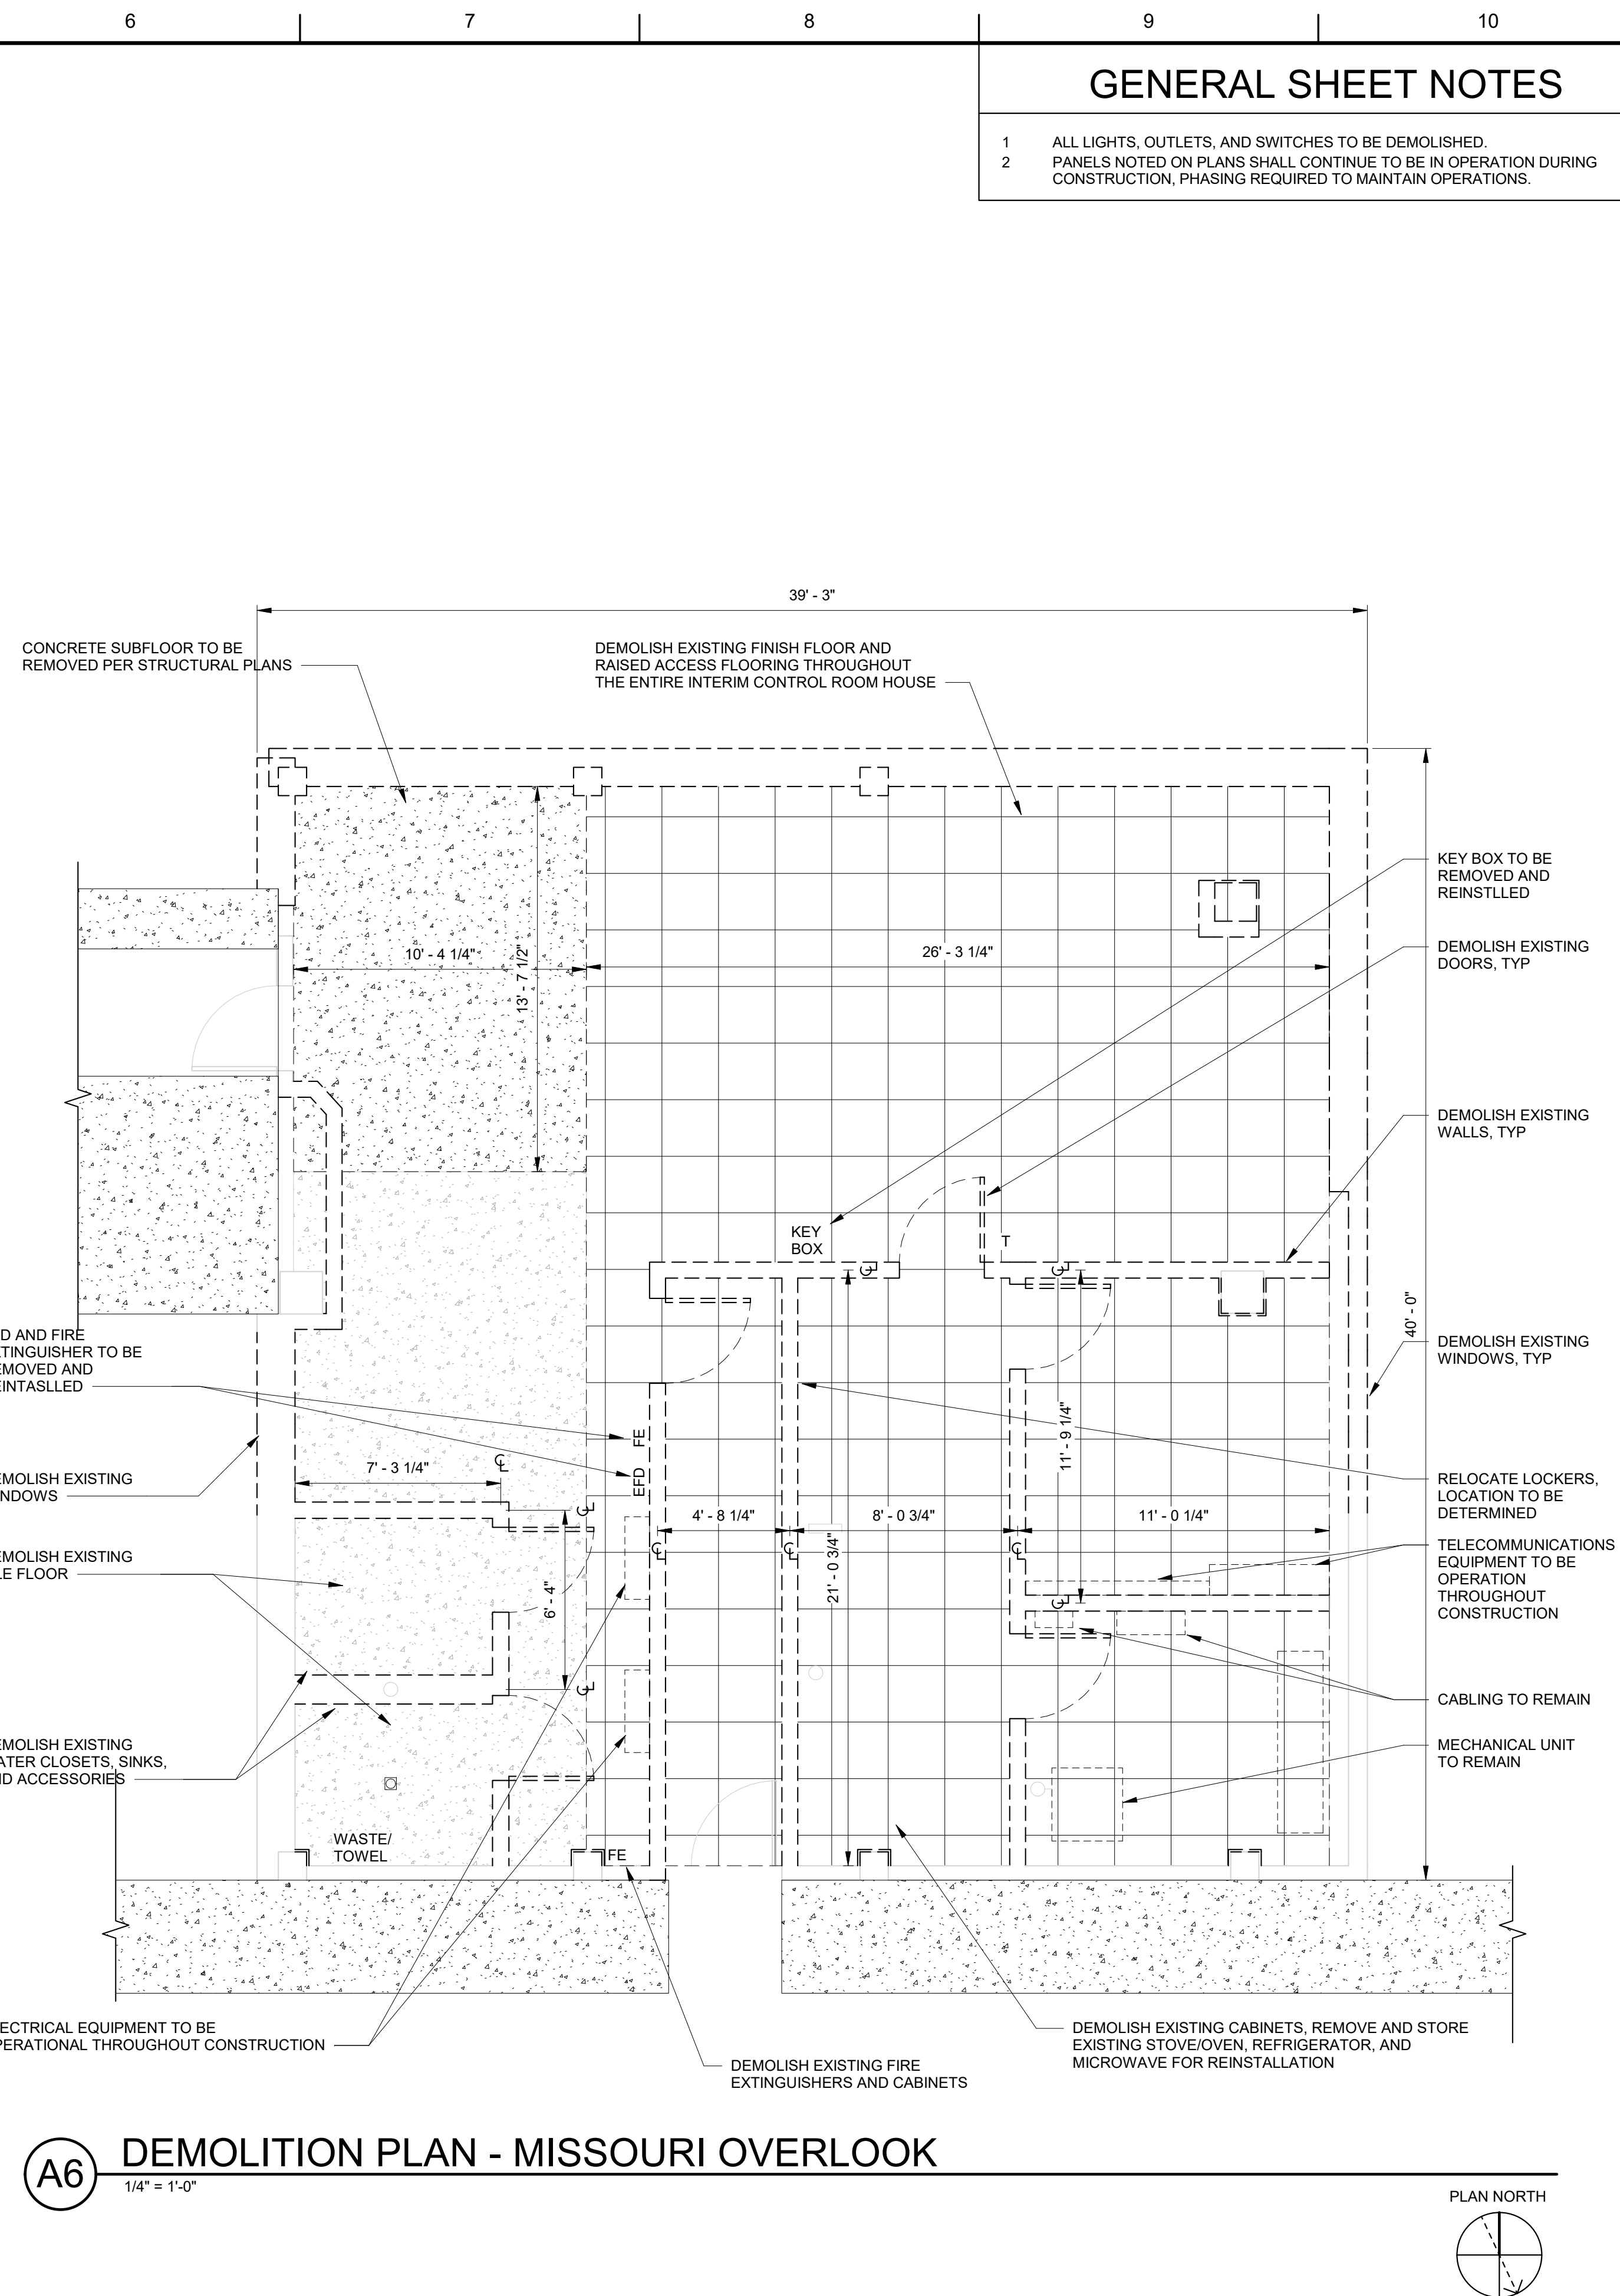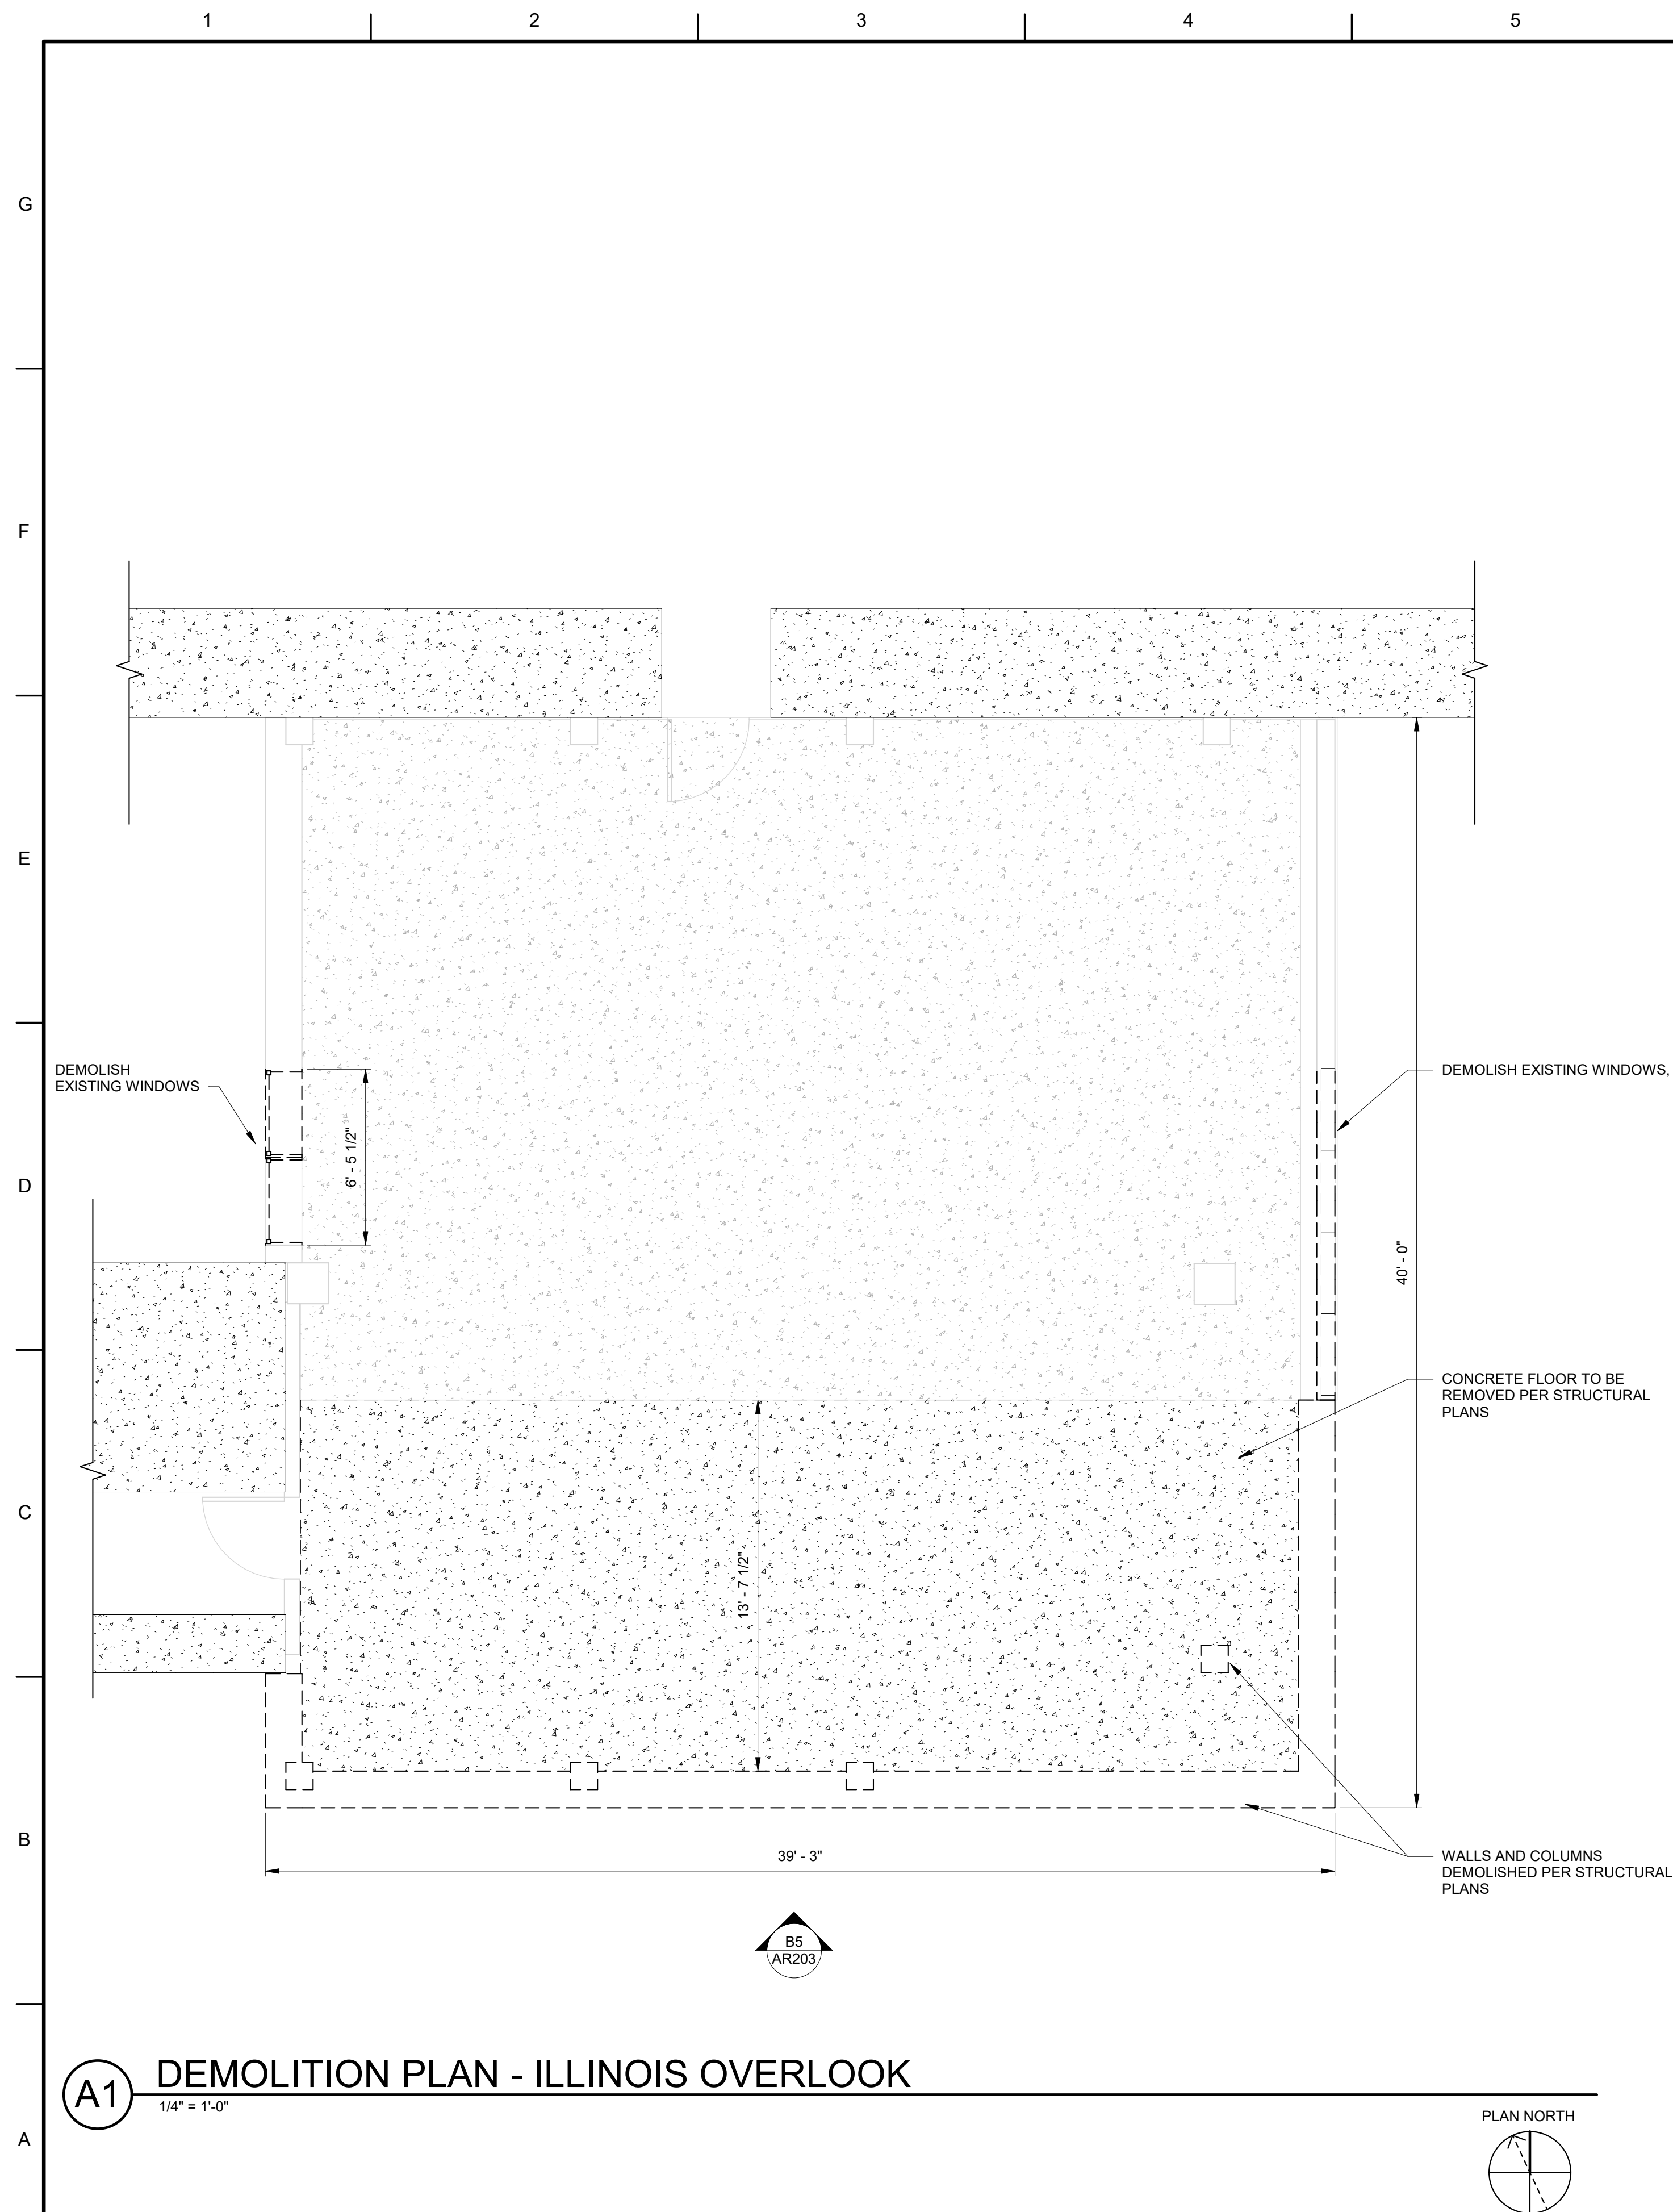

GENERAL SHEET NOTES

- 1 ALL LIGHTS, OUTLETS, AND SWITCHES TO BE DEMOLISHED.
2 PANELS NOTED ON PLANS SHALL CONTINUE TO BE IN OPERATION DURING
CONSTRUCTION, PHASING REQUIRED TO MAINTAIN OPERATIONS.

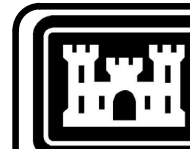

**US Army Corps
of Engineers®**


[illegible]

US ARMY CORPS OF ENGINEERS ST. LOUIS DISTRICT ST. LOUIS, MISSOURI 63103	DESIGNED BY:	MY	ISSUE DATE:	MAY 2021
	DRAWN BY:	MY	SOLICITATION NO.:	W912P9-21-R-0011
	CHECKED BY:		CONTRACT NO.:	
	SUBMITTED BY:			
	SMH			
	SIZE:			

MEL PRICE LOCKS AND DAM
MAIN LOCK OVERLOOK ALTERATIONS
ALTON, ILLINOIS
MISSISSIPPI RIVER

SHEET ID



AD102

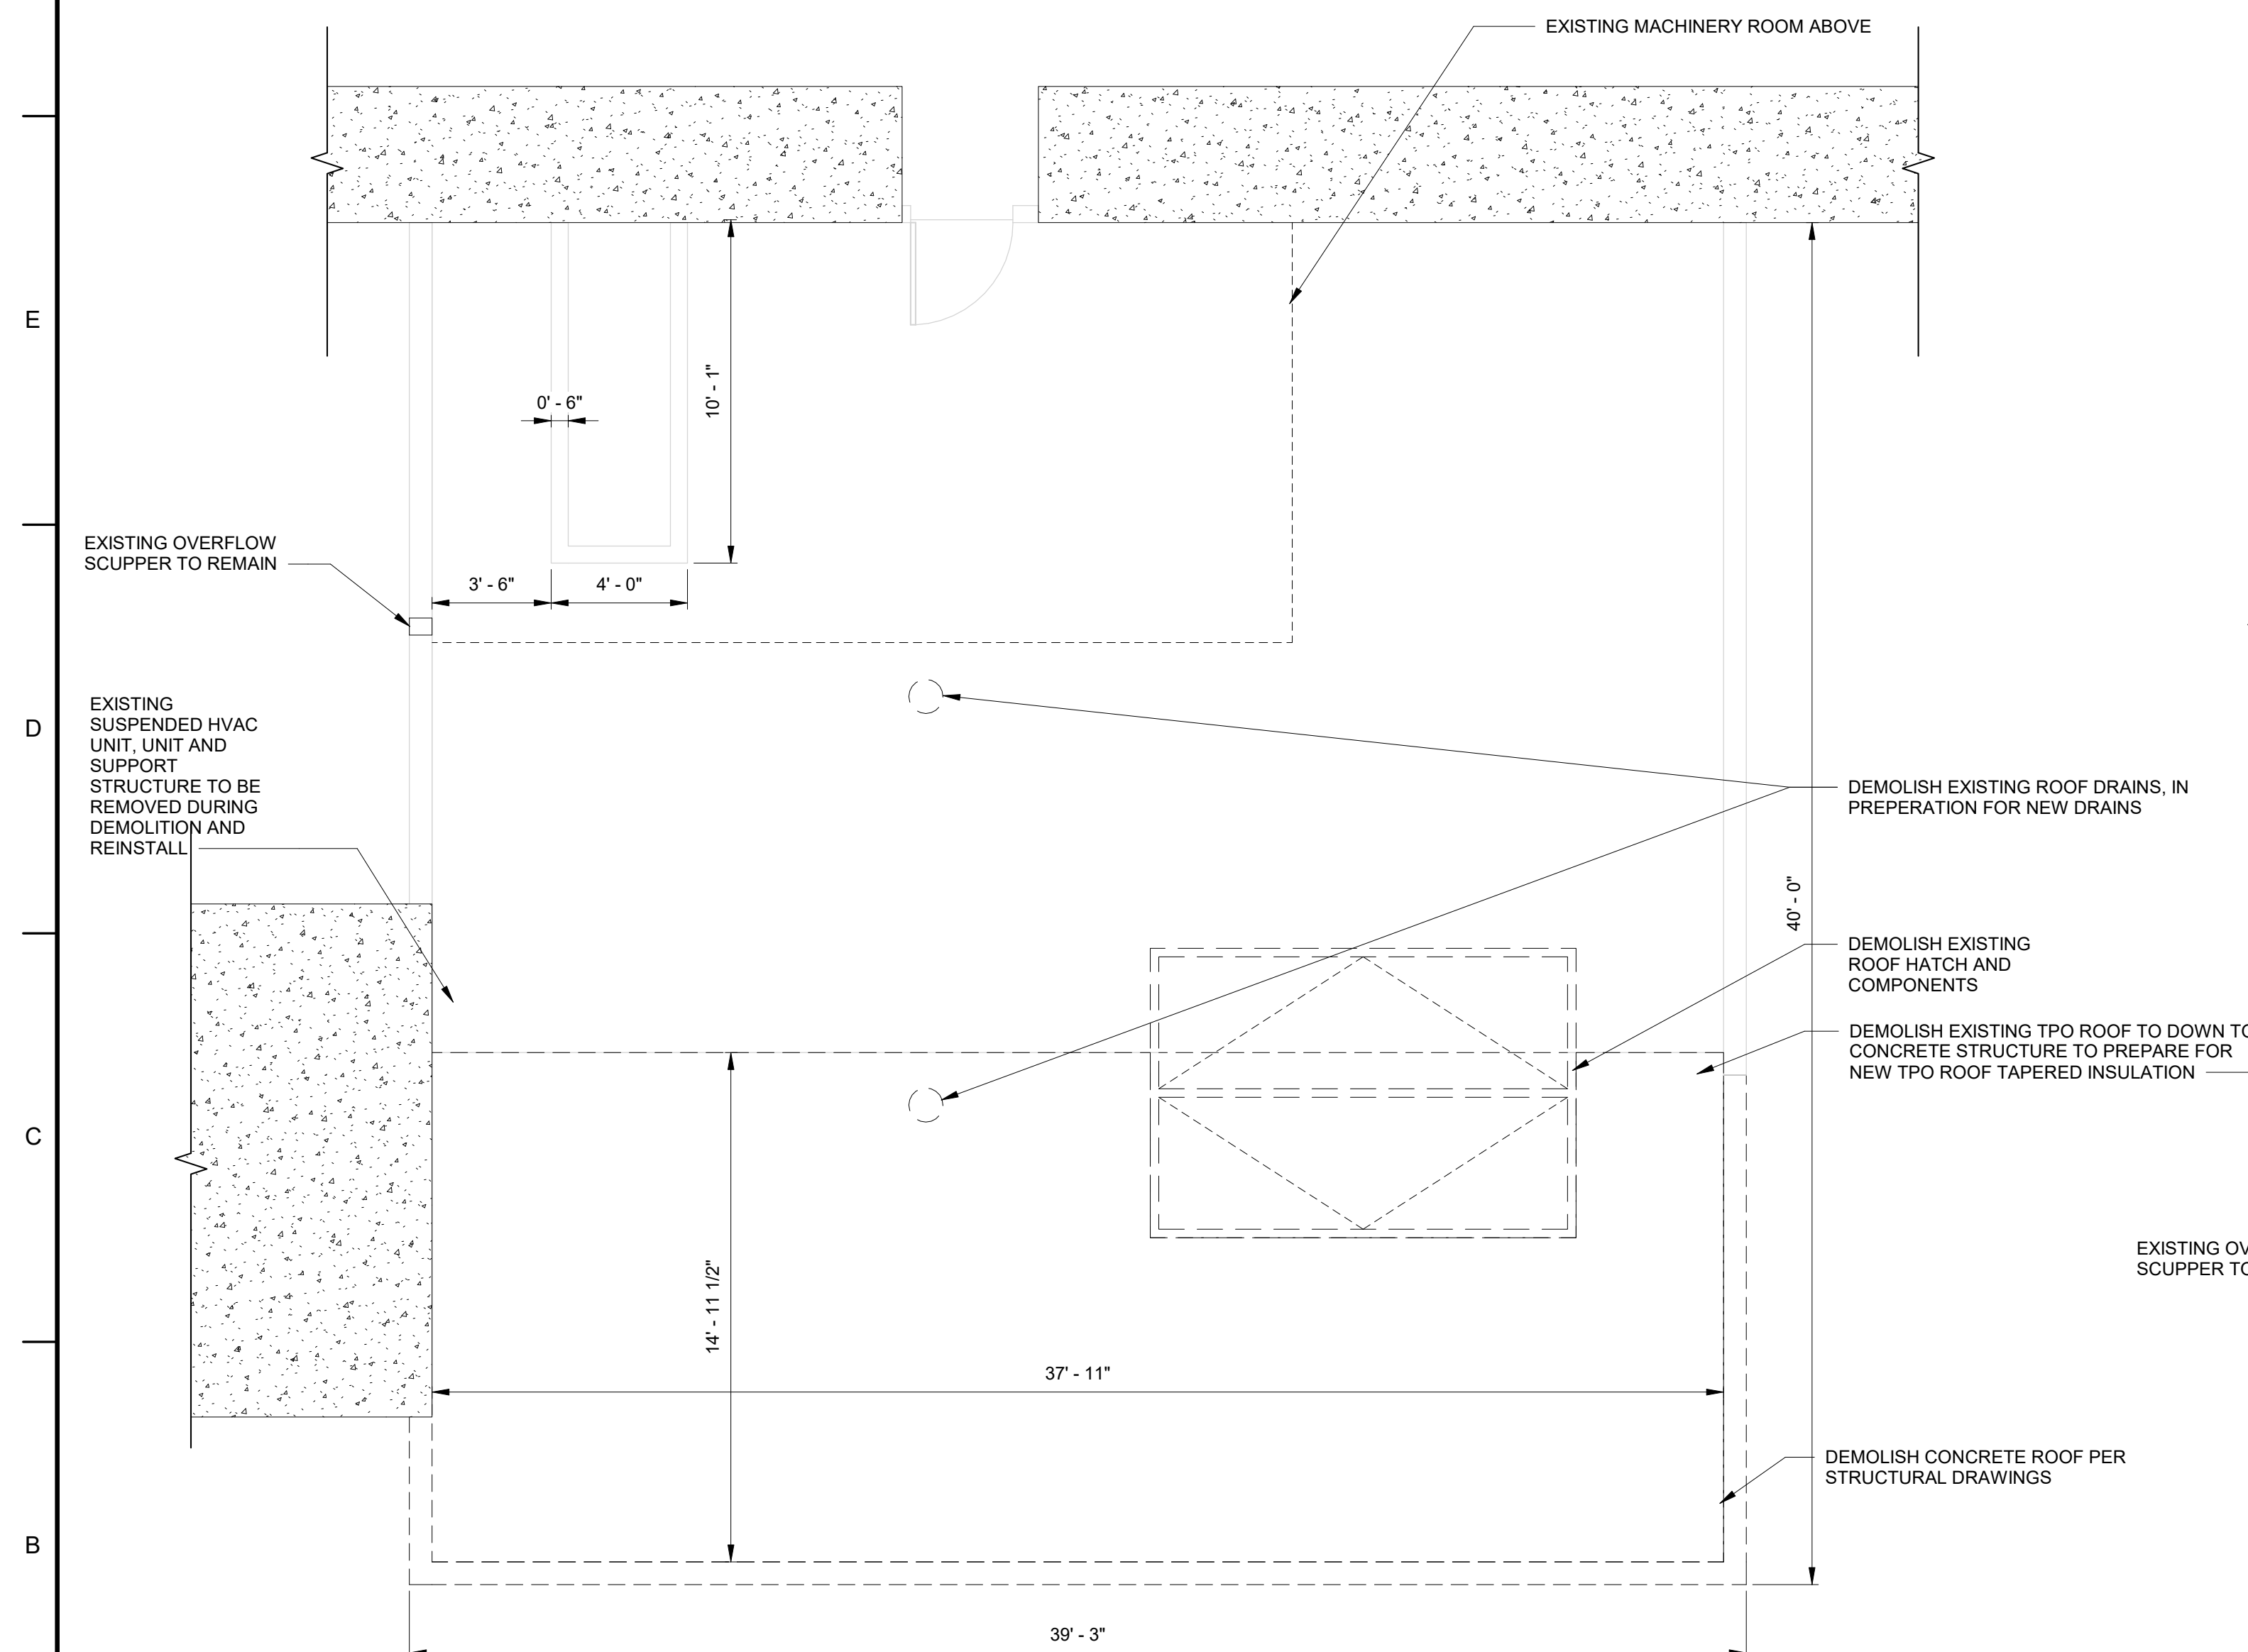

1 DEMOLITION ROOF PLAN - ILLINOIS OVERLOOK

1/4" = 1'-0"


PLAN NORTH

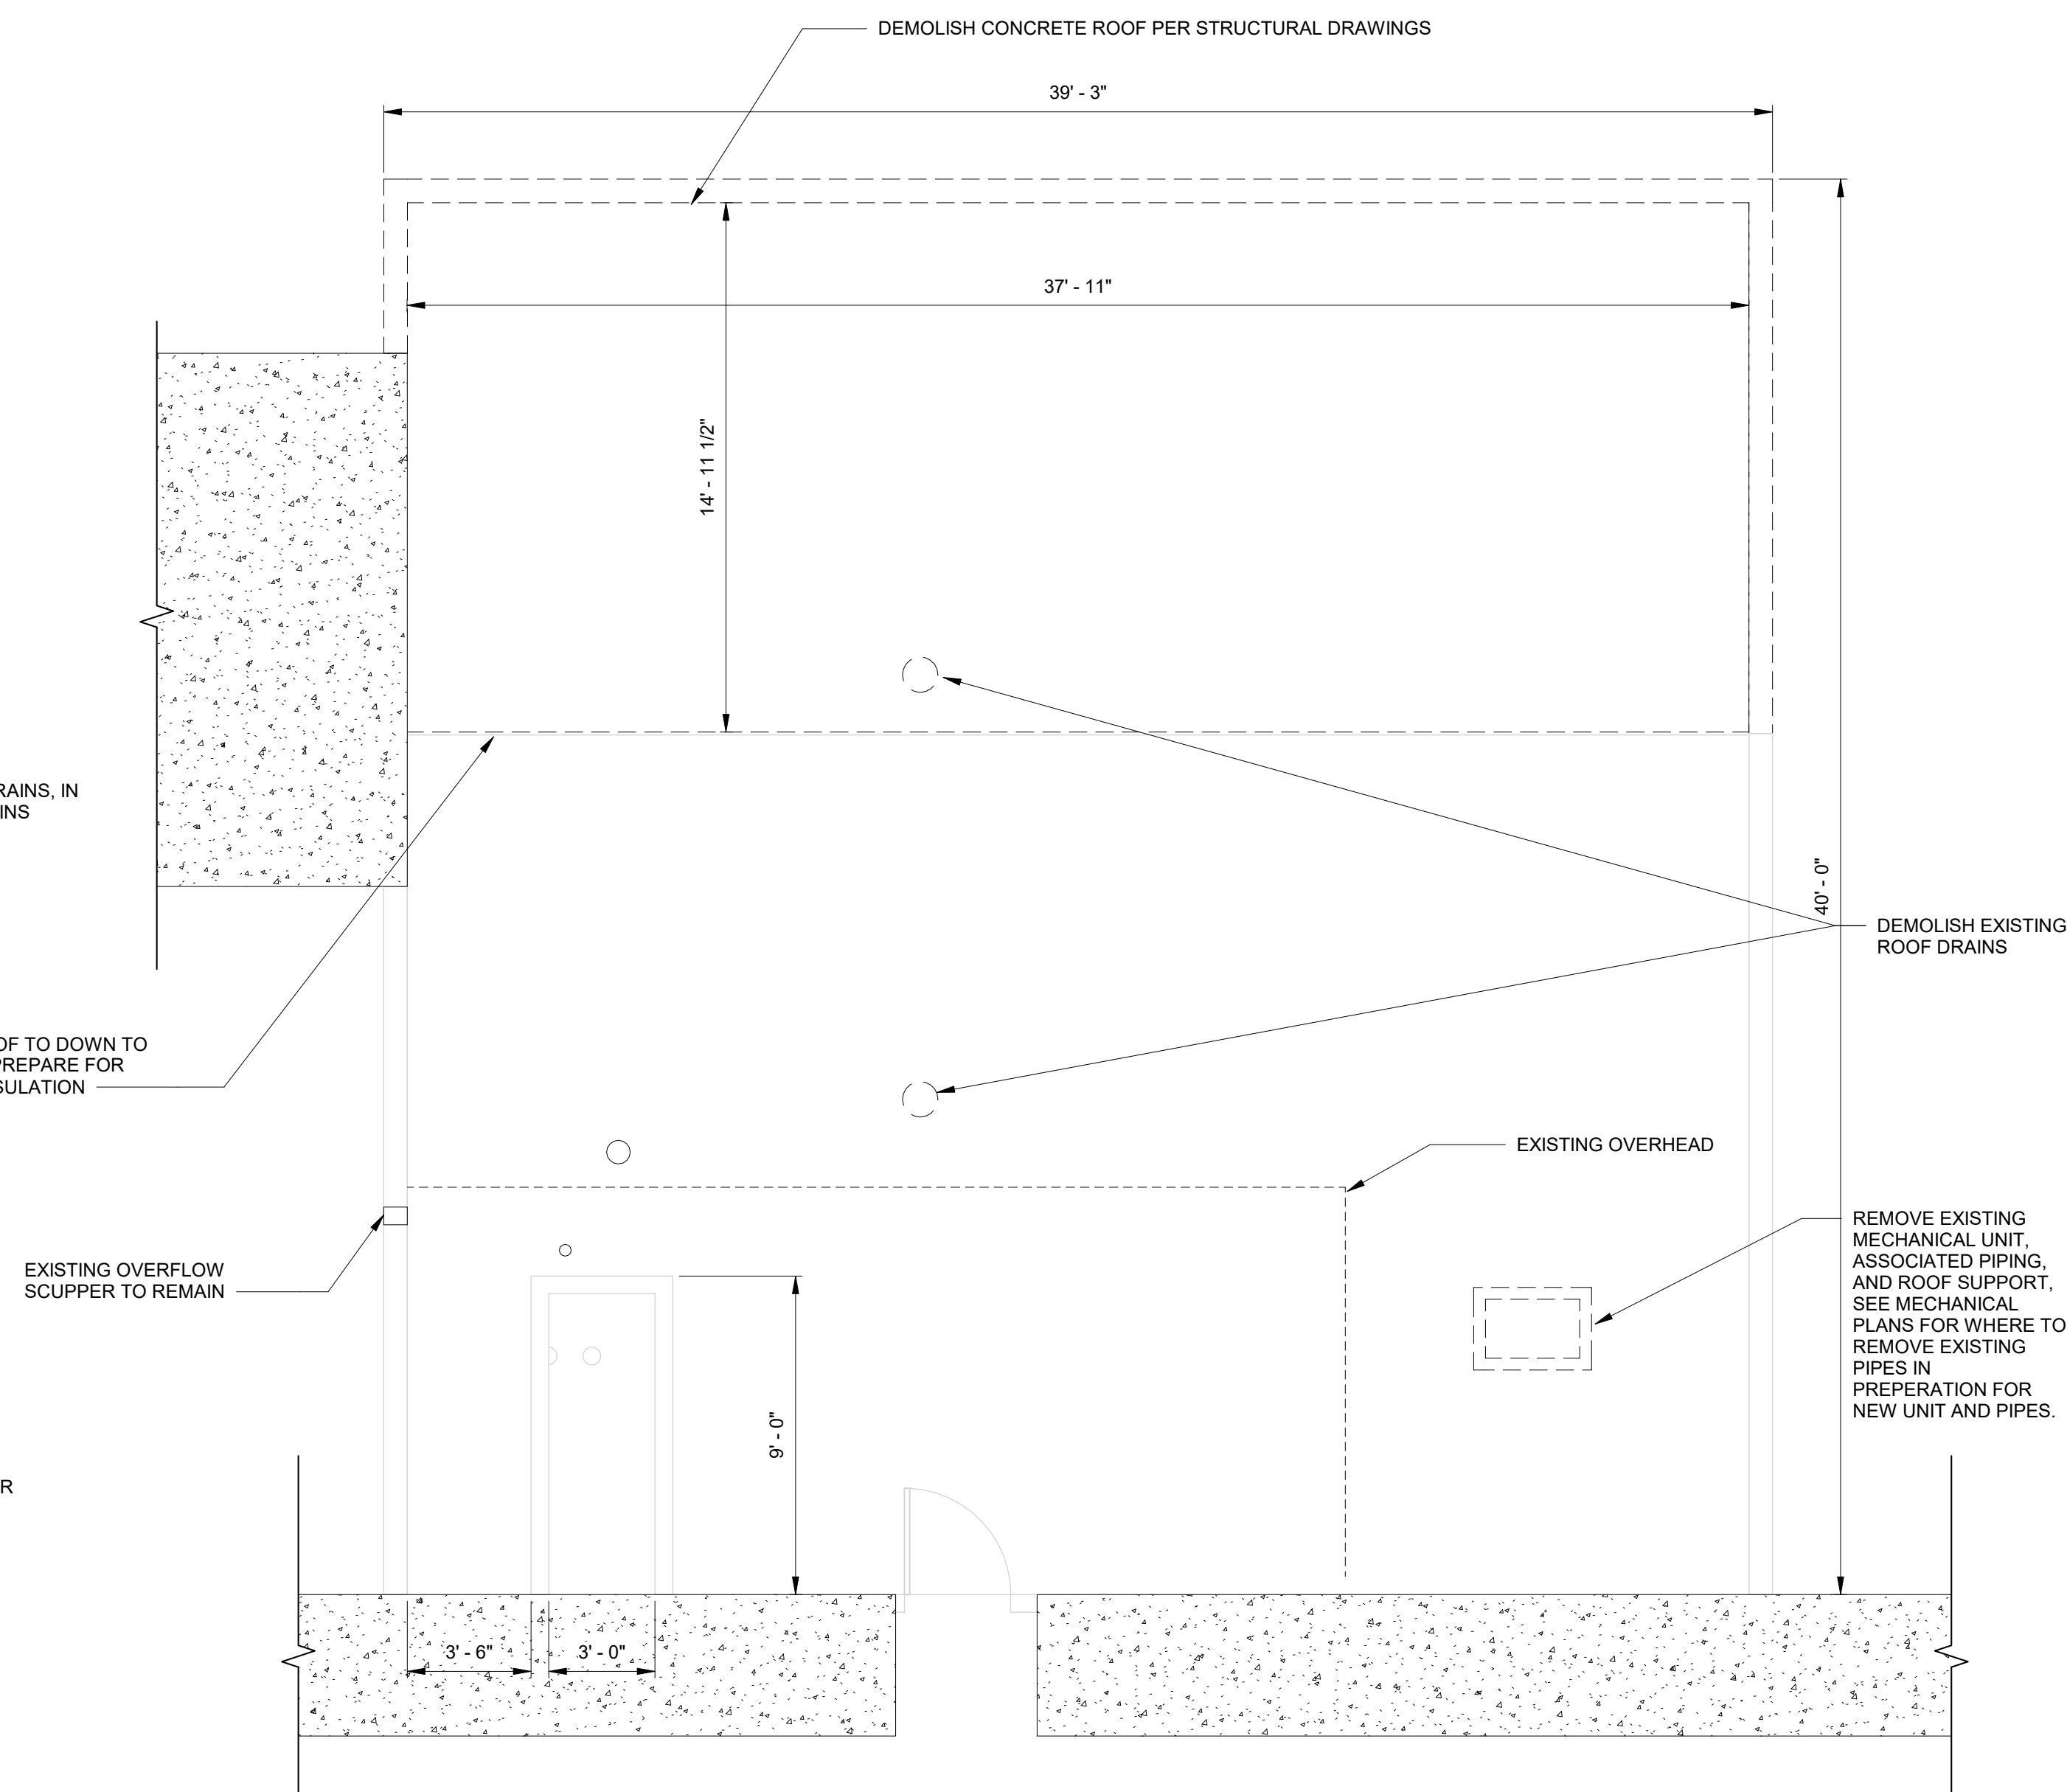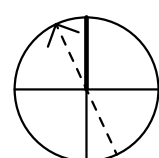


16 DEMOLITION ROOF PLAN - MISSOURI OVERLOOK


1/4" = 1'-0"

PLAN NORTH

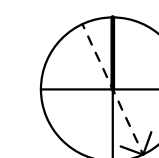


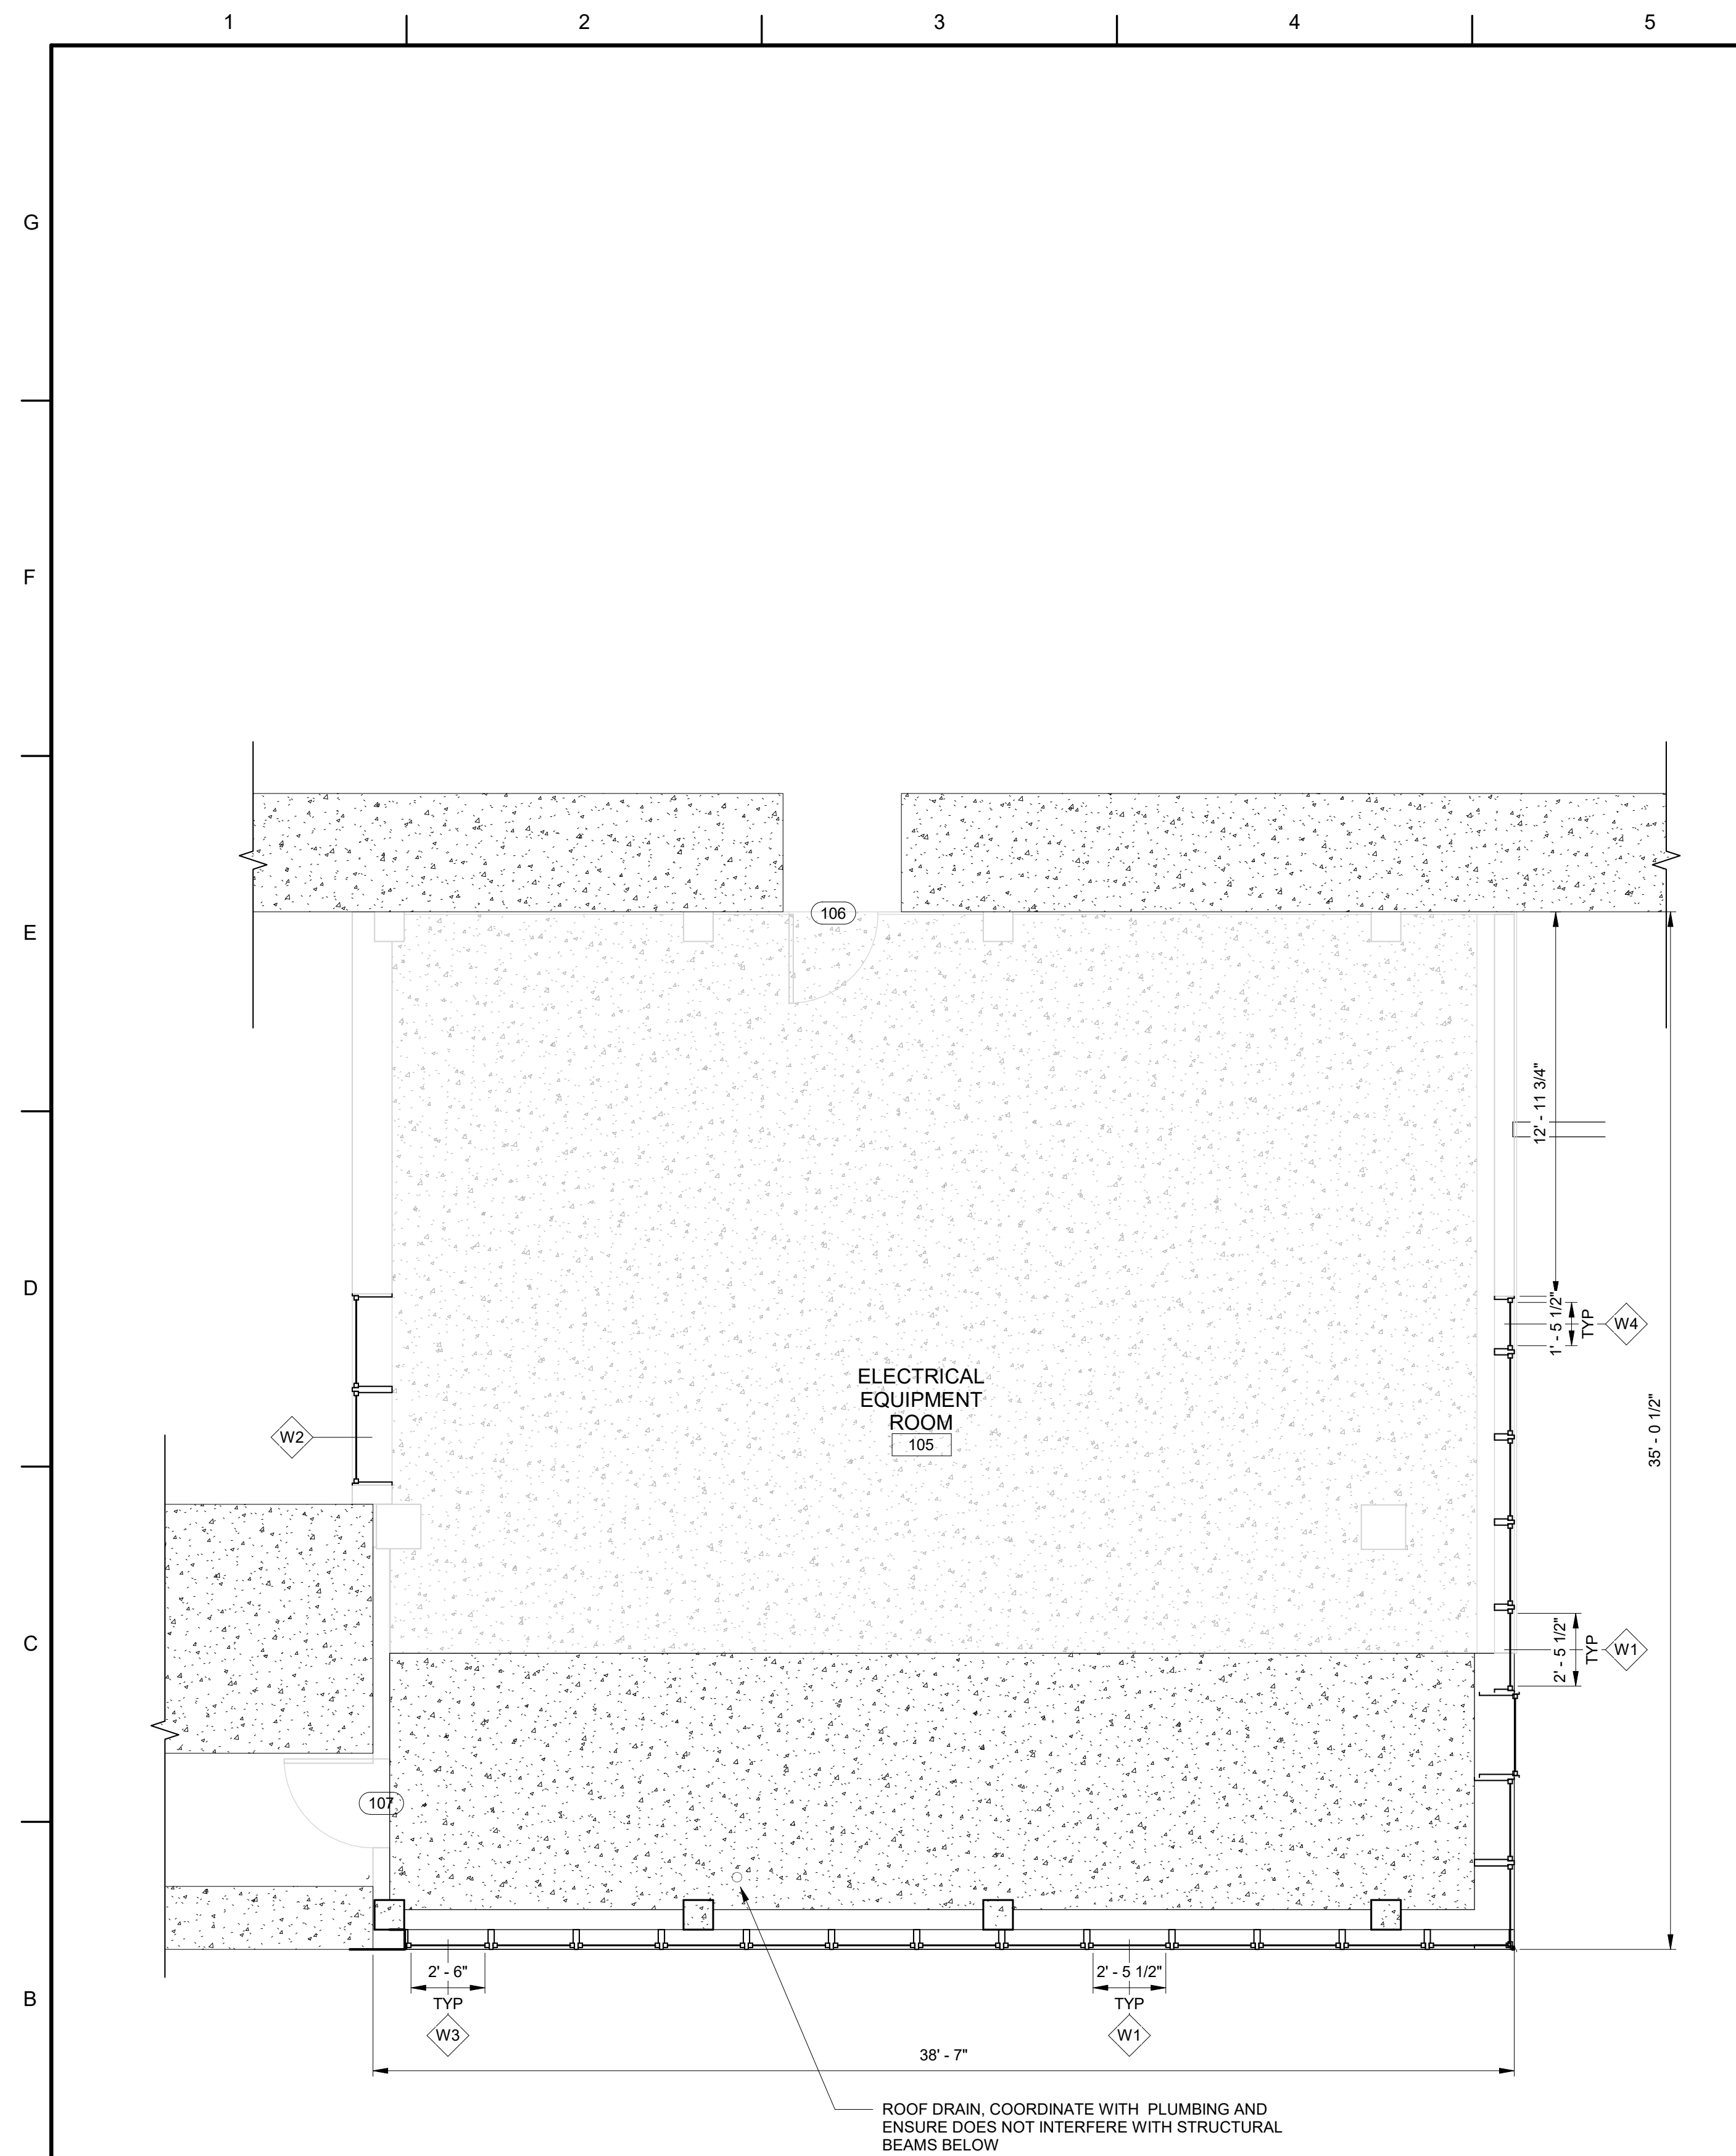

A1 FLOOR PLAN - ILLINOIS OVERLOOK
1/4" = 1'-0"
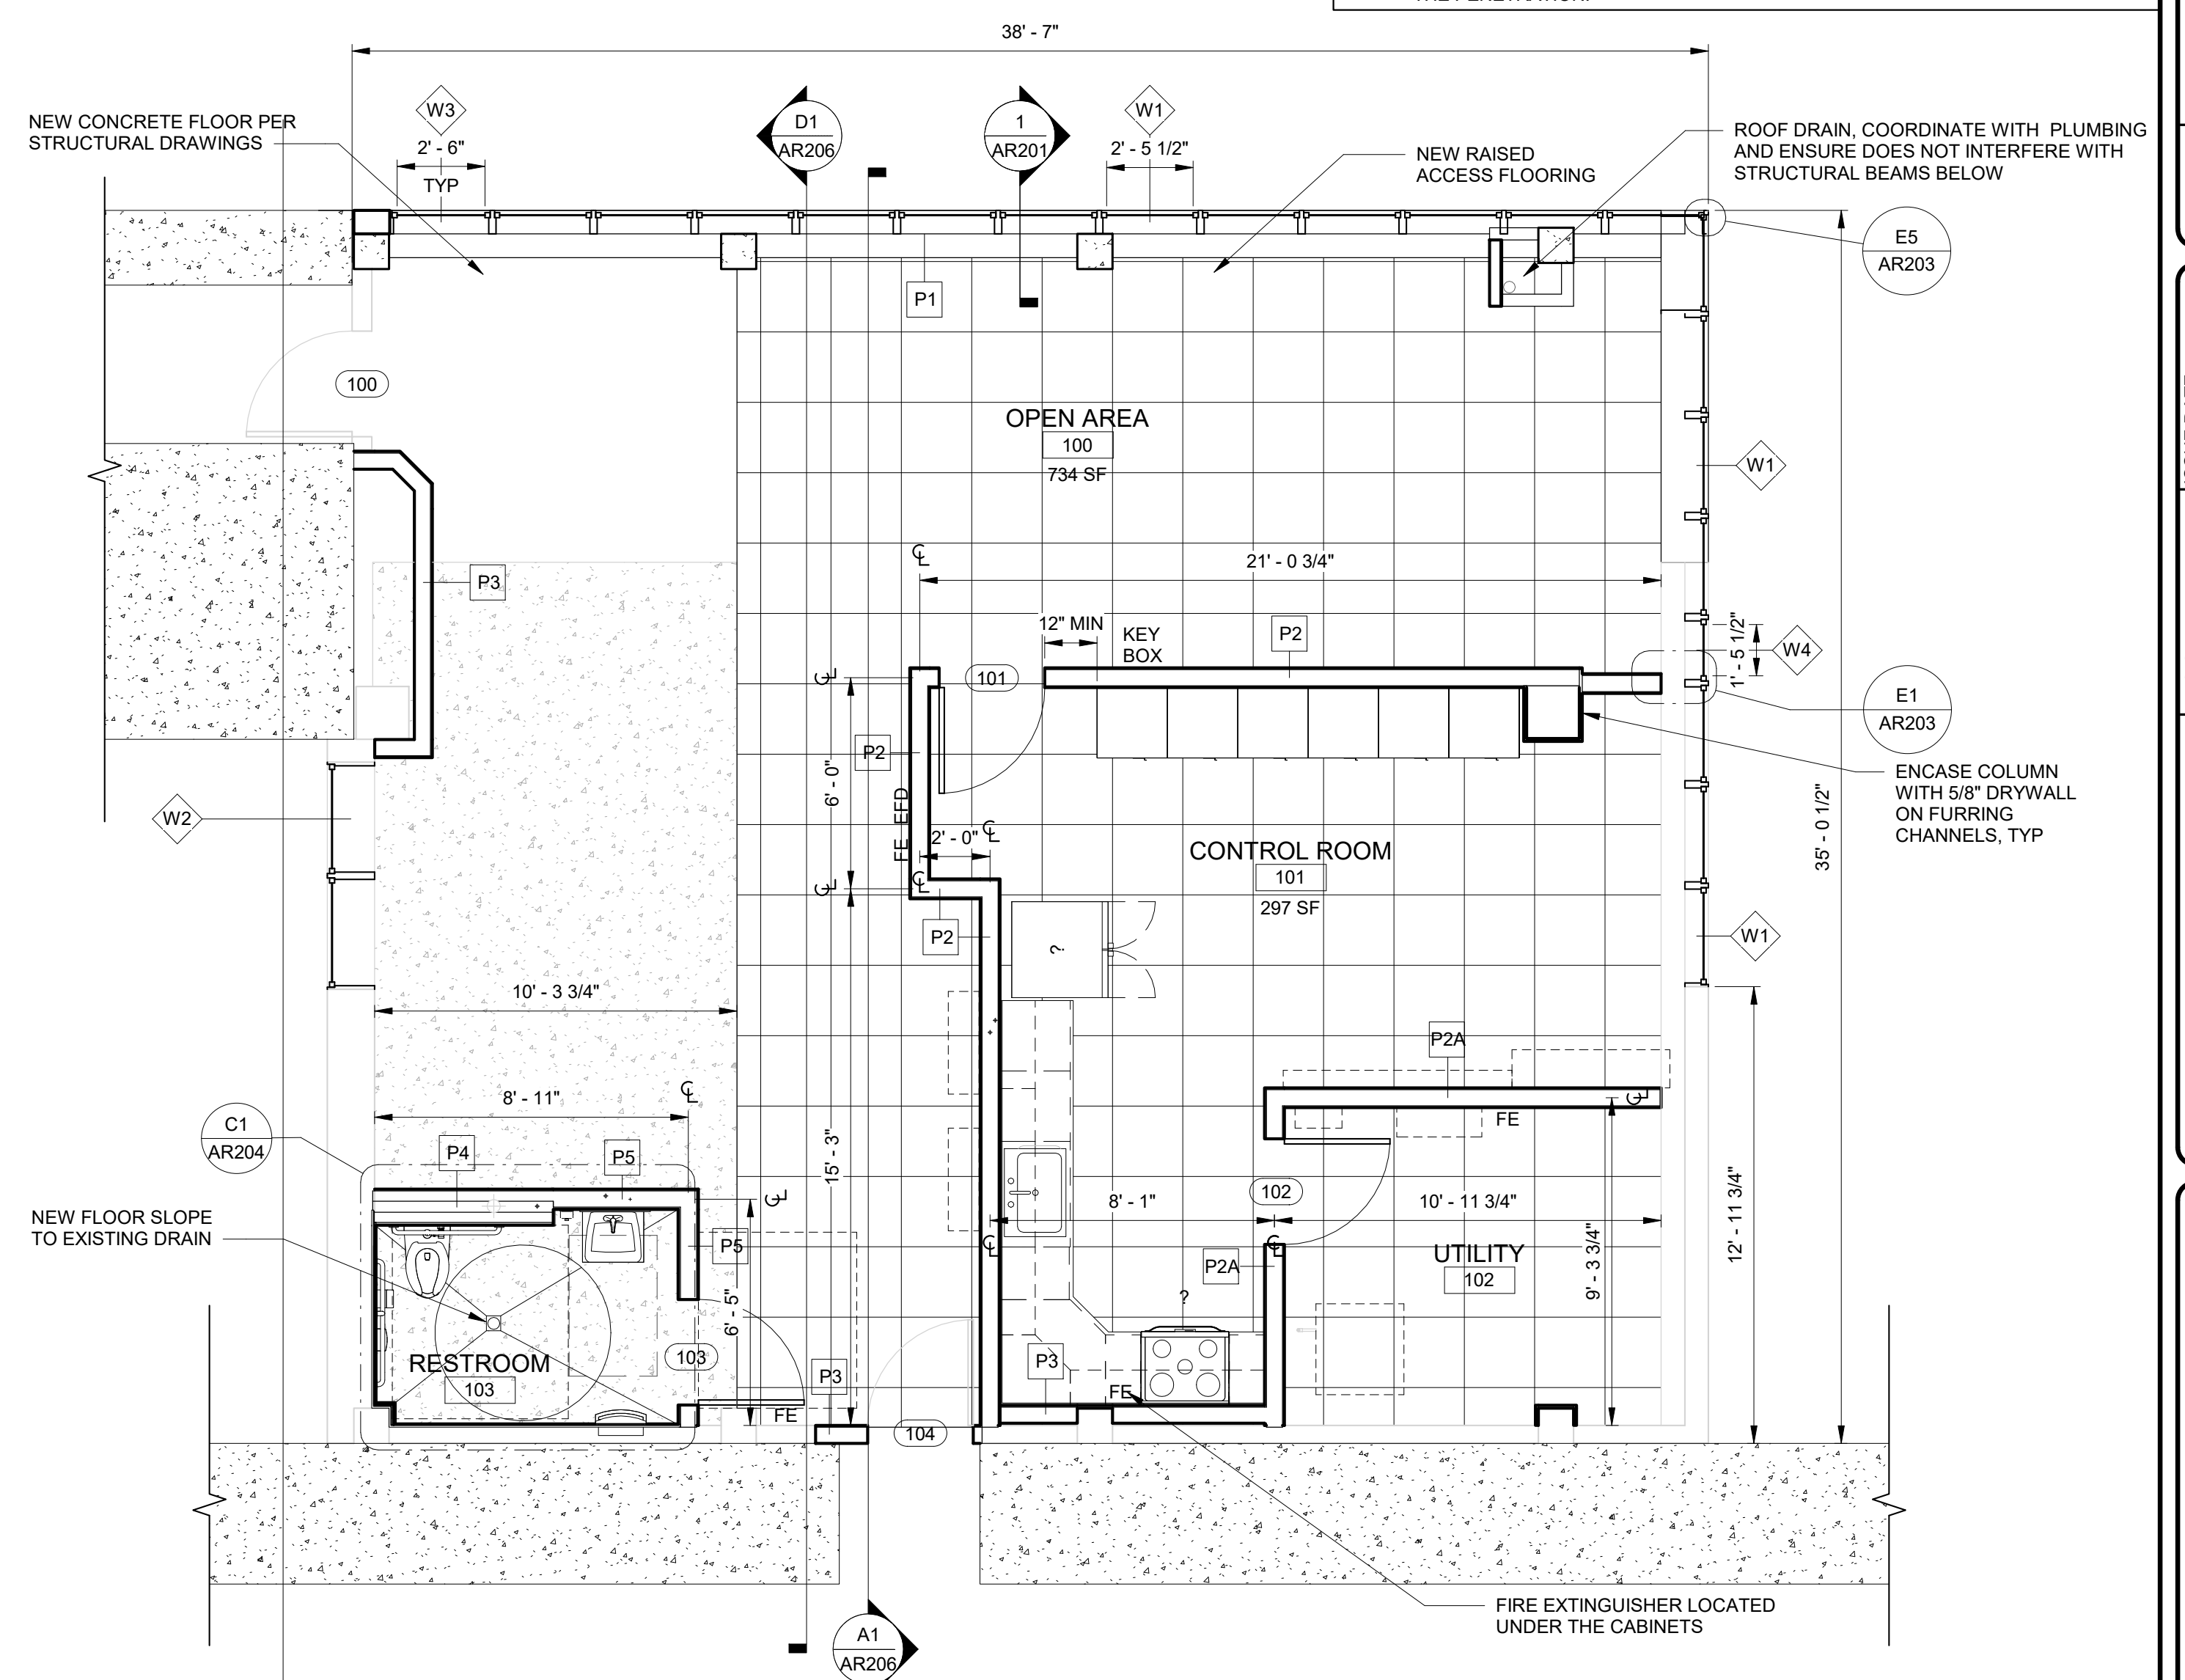
$$1/4'' = 1'-0''$$


A6 FLOOR PLAN - MISSOURI OVERLOOK
1/4" = 1'-0"
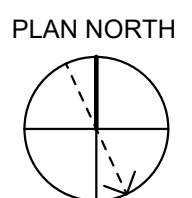
$$1/4'' = 1'-0''$$


GENERAL SHEET NOTES

- 1 VERIFY ALL DIMENSIONS IN FIELD PRIOR TO ORDERING AFFECTED MATERIALS, EQUIPMENT, MILLWORK, ETC.
- 2 REFERENCE STRUCTURAL, PLUMBING, MECHANICAL & ELECTRICAL DOCUMENTS FOR ADDITIONAL REQUIREMENTS.
- 3 REFERENCE INTERIOR DESIGN DRAWINGS FOR ADDITIONAL INFORMATION.
- 4 INFORMATION PROVIDED DOES NOT RELIEVE THE CONTRACTOR OF RESPONSIBILITY TO FIELD VERIFY ACTUAL QUANTITIES, DIMENSIONS & CONDITIONS.
- 5 ALL WORK SHALL COMPLY WITH APPLICABLE LOCAL, STATE & NATIONAL BUILDING CODES.
- 6 ALL WORK OF EVERY CHARACTER SHALL BE LAID OUT BY THE CONTRACTOR WHO SHALL BE RESPONSIBLE FOR THE CORRECT FIT & SHALL VERIFY ALL DIMENSIONS & CONDITIONS AT THE BUILDING SITE PRIOR TO CONSTRUCTION.
- 7 DO NOT SCALE DRAWINGS. FOLLOW WRITTEN DIMENSIONS ONLY.
- 8 CONTRACTOR SHALL VERIFY ALL DIMENSIONS & CONDITIONS AT THE SITE. THE CONTRACTING OFFICER SHALL BE NOTIFIED OF ANY DISCREPANCIES BETWEEN THE DOCUMENTS & ACTUAL SITE & CONDITIONS PRIOR TO PROCEEDING WITH CONSTRUCTION.
- 9 CONTRACTOR SHALL COORDINATE ALL WORK OF EVERY TRADE & CHARACTER OF THE PROJECT. THIS CONTRACTOR SHALL BE RESPONSIBLE FOR MEANS, METHOD & SAFETY OF CONSTRUCTION.
- 10 PROVIDE BLOCKING AT WALLS CONTAINING CABINETS, RESTROOM EQUIPMENT, HANDRAILS, KITCHEN EQUIPMENT, & OTHER MISCELLANEOUS IMPROVEMENTS REQUIRING BRACING.
- 11 PROVIDE A UL LISTED RANGE TOP EXTINGUISHER CONNECTED TO THE FACILITY FIRE ALARM SYSTEM FOR SHUT OFF ELECTRIC POWER TO THE STOVE.
- 12 PENETRATIONS IN FIRE RATED SEPARATIONS SHOULD BE SEALED WITH THE SAME FIRE RATING AS THE WALL ASSEMBLY. THE PENETRATION SHOULD BE SEALED BY AN APPROVED CONTRACTOR. SEALED PENETRATION SHOULD BE DATED, INCLUDE THE FIRE RATING LABEL AND THE CONTRACTOR THAT SEALED THE PENETRATION.



**US Army Corps
of Engineers®**

[illegible]

US ARMY CORPS OF ENGINEERS ST. LOUIS DISTRICT ST. LOUIS, MISSOURI 63103	DRAWN BY: WY	DATE: MAY 2021
	CHECKED BY: FA	CONTRACT NO.: W912P9-21-R-001
	SUBMITTED BY: SMH	
	PROJECT NO.: ANSLD	

MAIN LOCK OVERLOOK ALTERATIONS
ALTON, ILLINOIS
MISSISSIPPI RIVER

ILLINOIS AND MISSOURI OVERLOOK
RECONSTRUCTION PLAN

SHEET ID

AR101

GENERAL SHEET NOTES


- 1 VERIFY ALL DIMENSIONS IN FIELD PRIOR TO ORDERING AFFECTED MATERIALS, EQUIPMENT, MILLWORK, ETC.
- 2 REFERENCE STRUCTURAL, PLUMBING, MECHANICAL & ELECTRICAL DOCUMENTS FOR ADDITIONAL REQUIREMENTS.
- 3 REFERENCE INTERIOR DESIGN DRAWINGS FOR ADDITIONAL INFORMATION.
- 4 INFORMATION PROVIDED DOES NOT RELIEVE THE CONTRACTOR OF RESPONSIBILITY TO FIELD VERIFY ACTUAL QUANTITIES, DIMENSIONS & CONDITIONS.
- 5 ALL WORK SHALL COMPLY WITH APPLICABLE LOCAL, STATE & NATIONAL BUILDING CODES.
- 6 ALL WORK OF EVERY CHARACTER SHALL BE LAID OUT BY THE CONTRACTOR WHO SHALL BE RESPONSIBLE FOR THE CORRECT FIT & SHALL VERIFY ALL DIMENSIONS & CONDITIONS AT THE BUILDING SITE PRIOR TO CONSTRUCTION.
- 7 DO NOT SCALE DRAWINGS. FOLLOW WRITTEN DIMENSIONS ONLY.
- 8 CONTRACTOR SHALL VERIFY ALL DIMENSIONS & CONDITIONS AT THE SITE. THE CONTRACTING OFFICE SHALL BE NOTIFIED OF ANY DISCREPANCIES BETWEEN THE DOCUMENTS & ACTUAL SITE & CONDITIONS PRIOR TO PROCEEDING WITH CONSTRUCTION.
- 9 CONTRACTOR SHALL COORDINATE ALL WORK OF EVERY TRADE & CHARACTER OF THE PROJECT. THIS CONTRACTOR SHALL BE RESPONSIBLE FOR MEANS, METHOD & SAFETY OF CONSTRUCTION.
- 10 PROVIDE BLOCKING AT WALLS CONTAINING CABINETS, RESTROOM EQUIPMENT, HANDRAILS, KITCHEN EQUIPMENT, & OTHER MISCELLANEOUS IMPROVEMENTS REQUIRING BRACING.
- 11 PROVIDE A UL LISTED RANGE TOP EXTINGUISHER CONNECTED TO THE FACILITY FIRE ALARM SYSTEM FOR SHUT OFF ELECTRIC POWER TO THE STOVE.
- 12 PENETRATIONS IN FIRE RATED SEPARATIONS SHOULD BE SEALED WITH THE SAME FIRE RATING AS THE WALL ASSEMBLY. THE PENETRATION SHOULD BE SEALED BY AN APPROVED CONTRACTOR. SEALED PENETRATION SHOULD BE DATED, INCLUDE THE FIRE RATING LABEL AND THE CONTRACTOR THAT SEALED THE PENETRATION.

[illegible]


US ARMY CORPS OF ENGINEERS ST. LOUIS DISTRICT ST. LOUIS, MISSOURI 63103	DRAWN BY:	SOLICITATION NO.:	
	MY	W912P5-21-R-0011	
	CHECKED BY:	CONTRACT NO.:	
	FA		
	SUBMITTED BY:		
	SWH		
	W912P5-21-R-0011		
	ANSI D		

ILLINOIS AND MISSOURI OVERLOOK ROOM ROOF
PLAN

SHEET ID
AR102


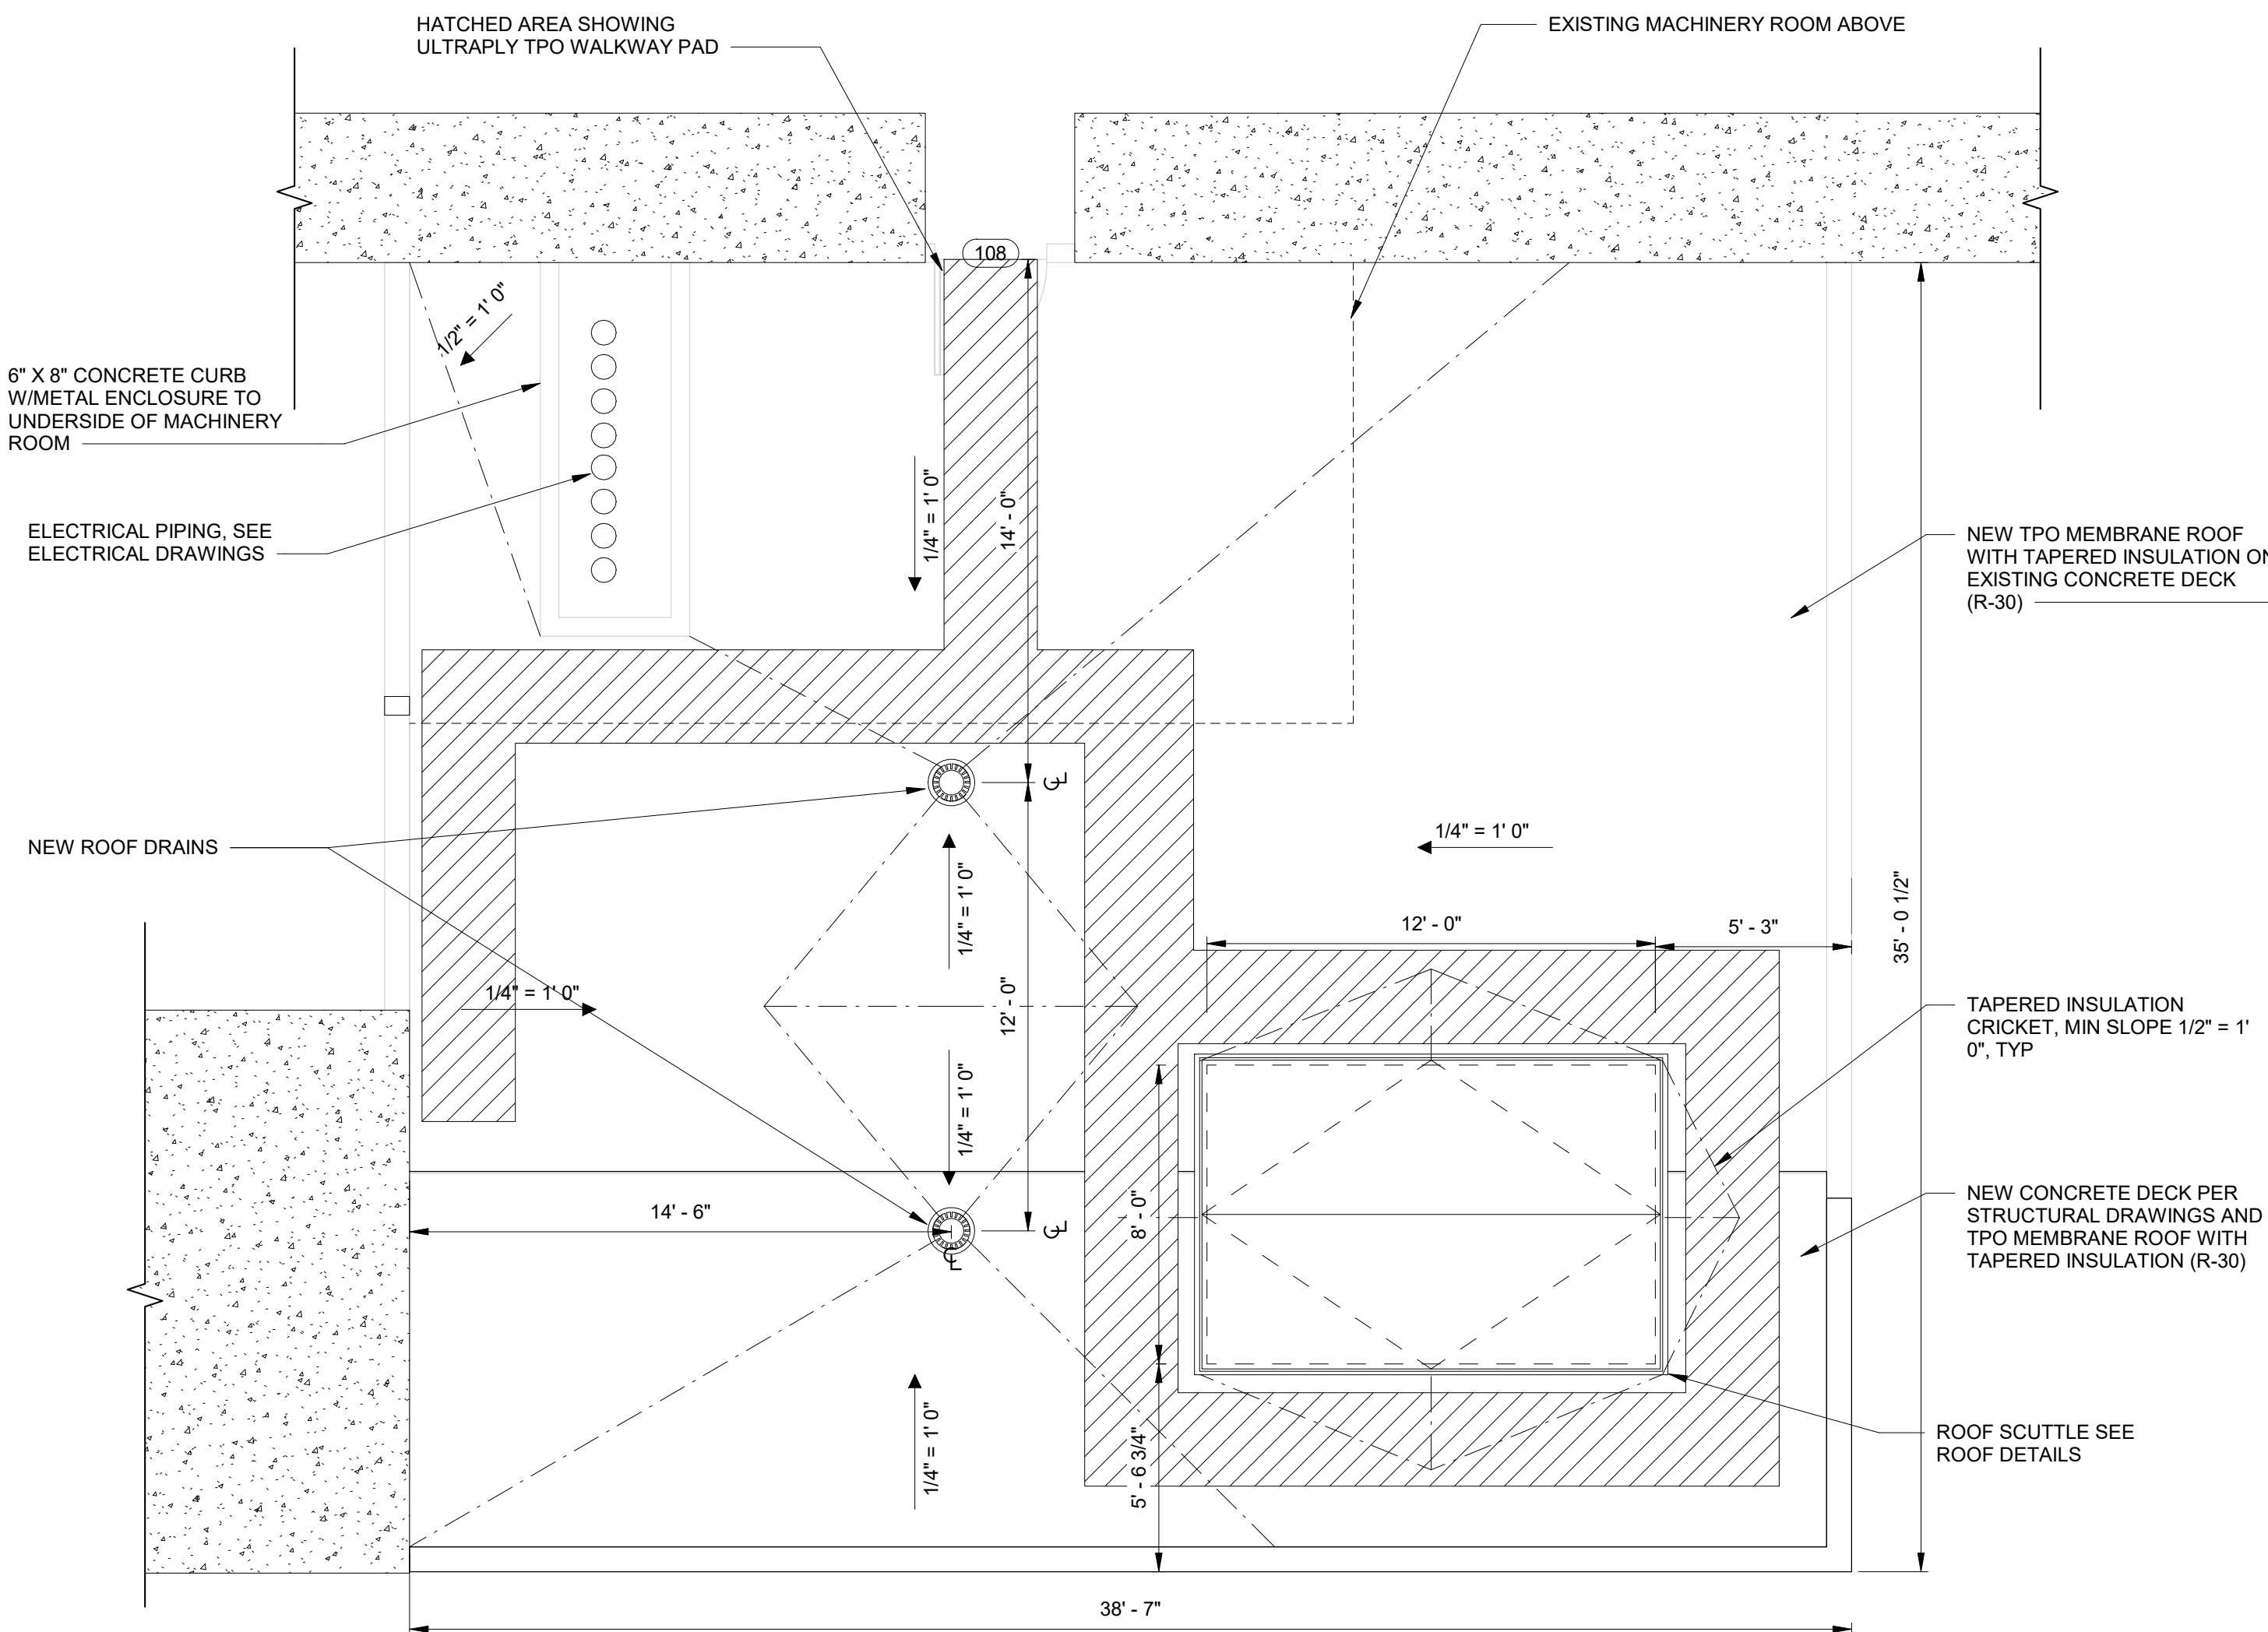


A1 ROOF PLAN - ILLINOIS OVERLOOK
1/4" = 1'-0"

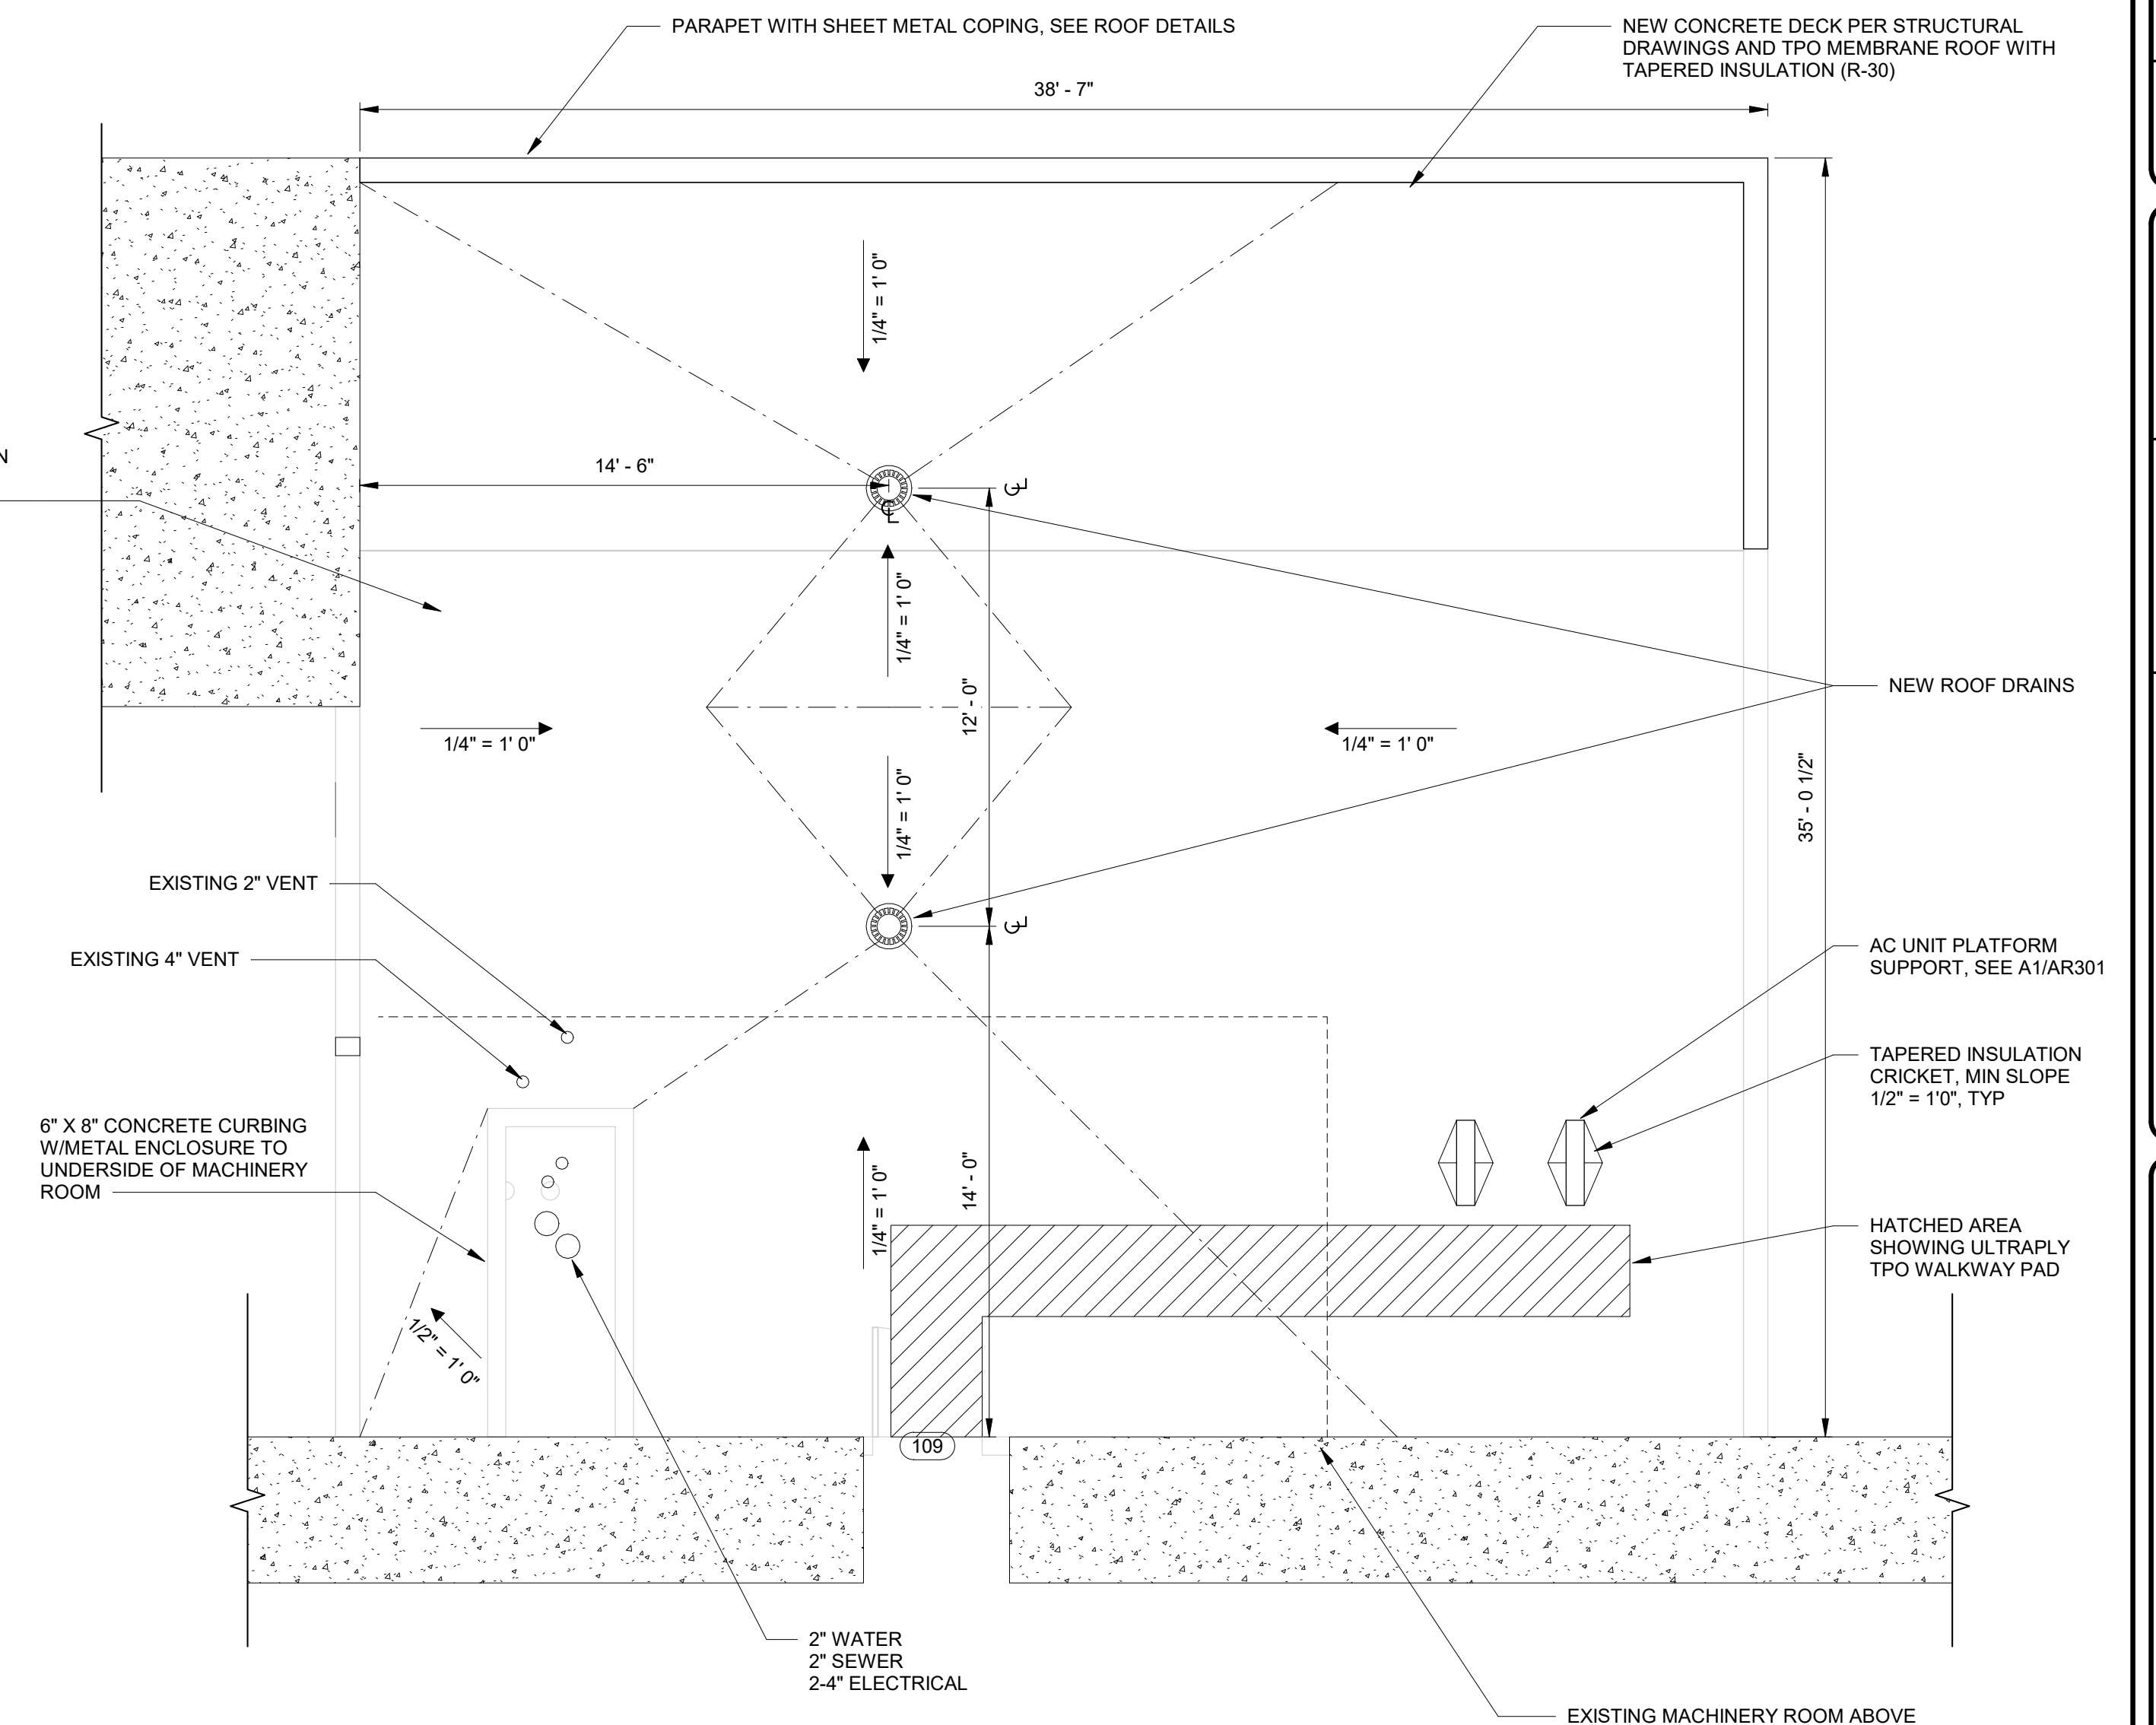

A6 ROOF PLAN - MISSOURI OVERLOOK
1/4" = 1'-0"



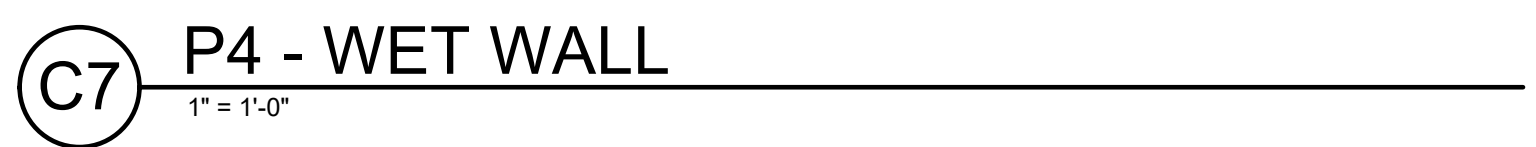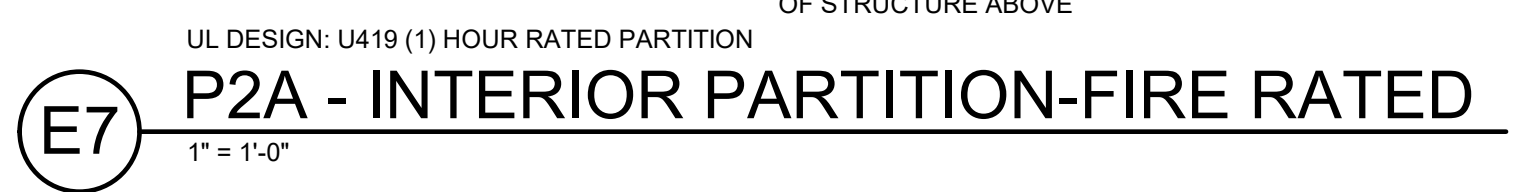








GENERAL SHEET NOTES

- 1 FINISH FRAME TO BE DARK BROWN (TYP)
2 CLEARED TEMPERED GLASS ACCORDING TO SPECIFICATIONS

Window Schedule

Type Mark	Sill Height	Width	Height	Count
W1	2' - 10 1/2"	2' - 10 1/2"	5' - 2 1/4"	38
W2	2' - 10 1/2"	3' - 2 3/4"	3' - 10 1/4"	4
W3	2' - 10 1/2"	2' - 11"	5' - 2 1/4"	2
W4	2' - 10 1/2"	1' - 10 1/2"	5' - 2 1/4"	2

1. MEASUREMENTS AND COUNTS SHOULD BE VERIFIED BY CONTRACTOR BEFORE ORDERING

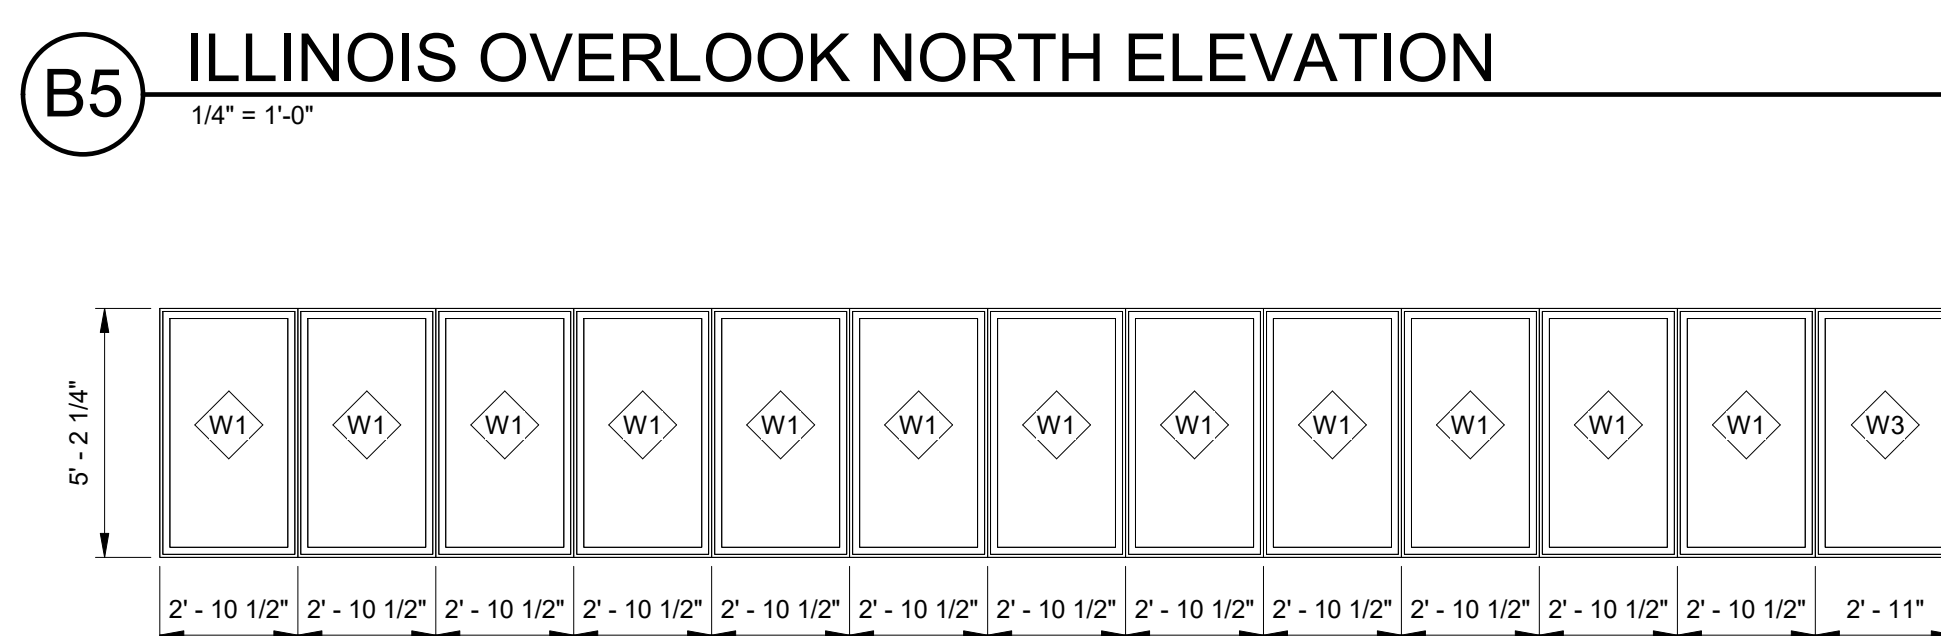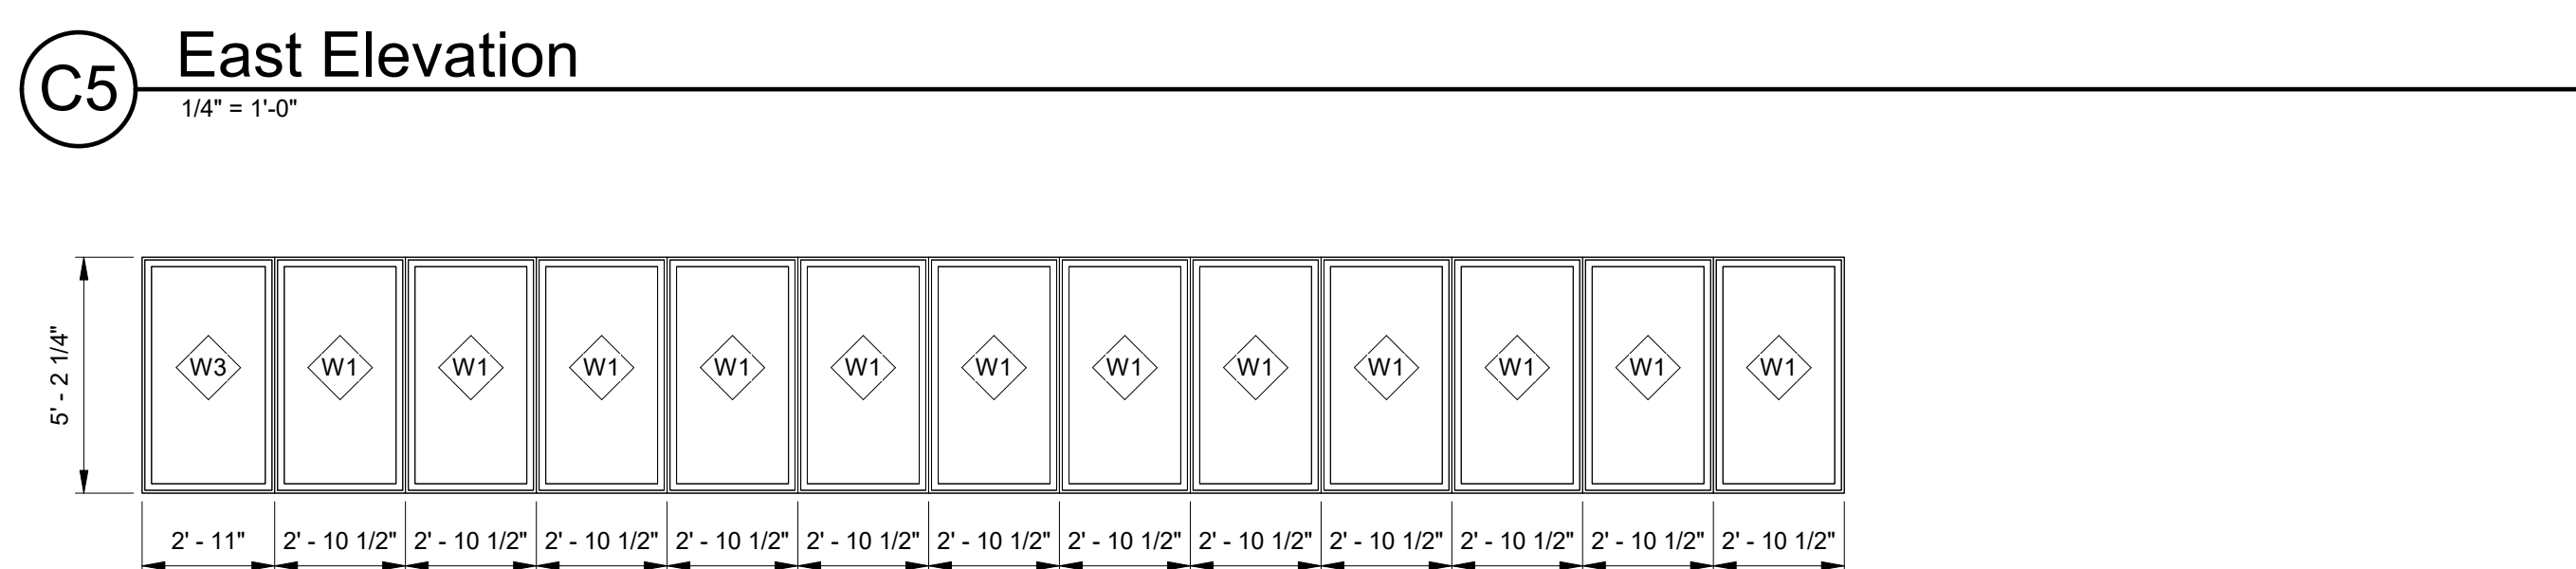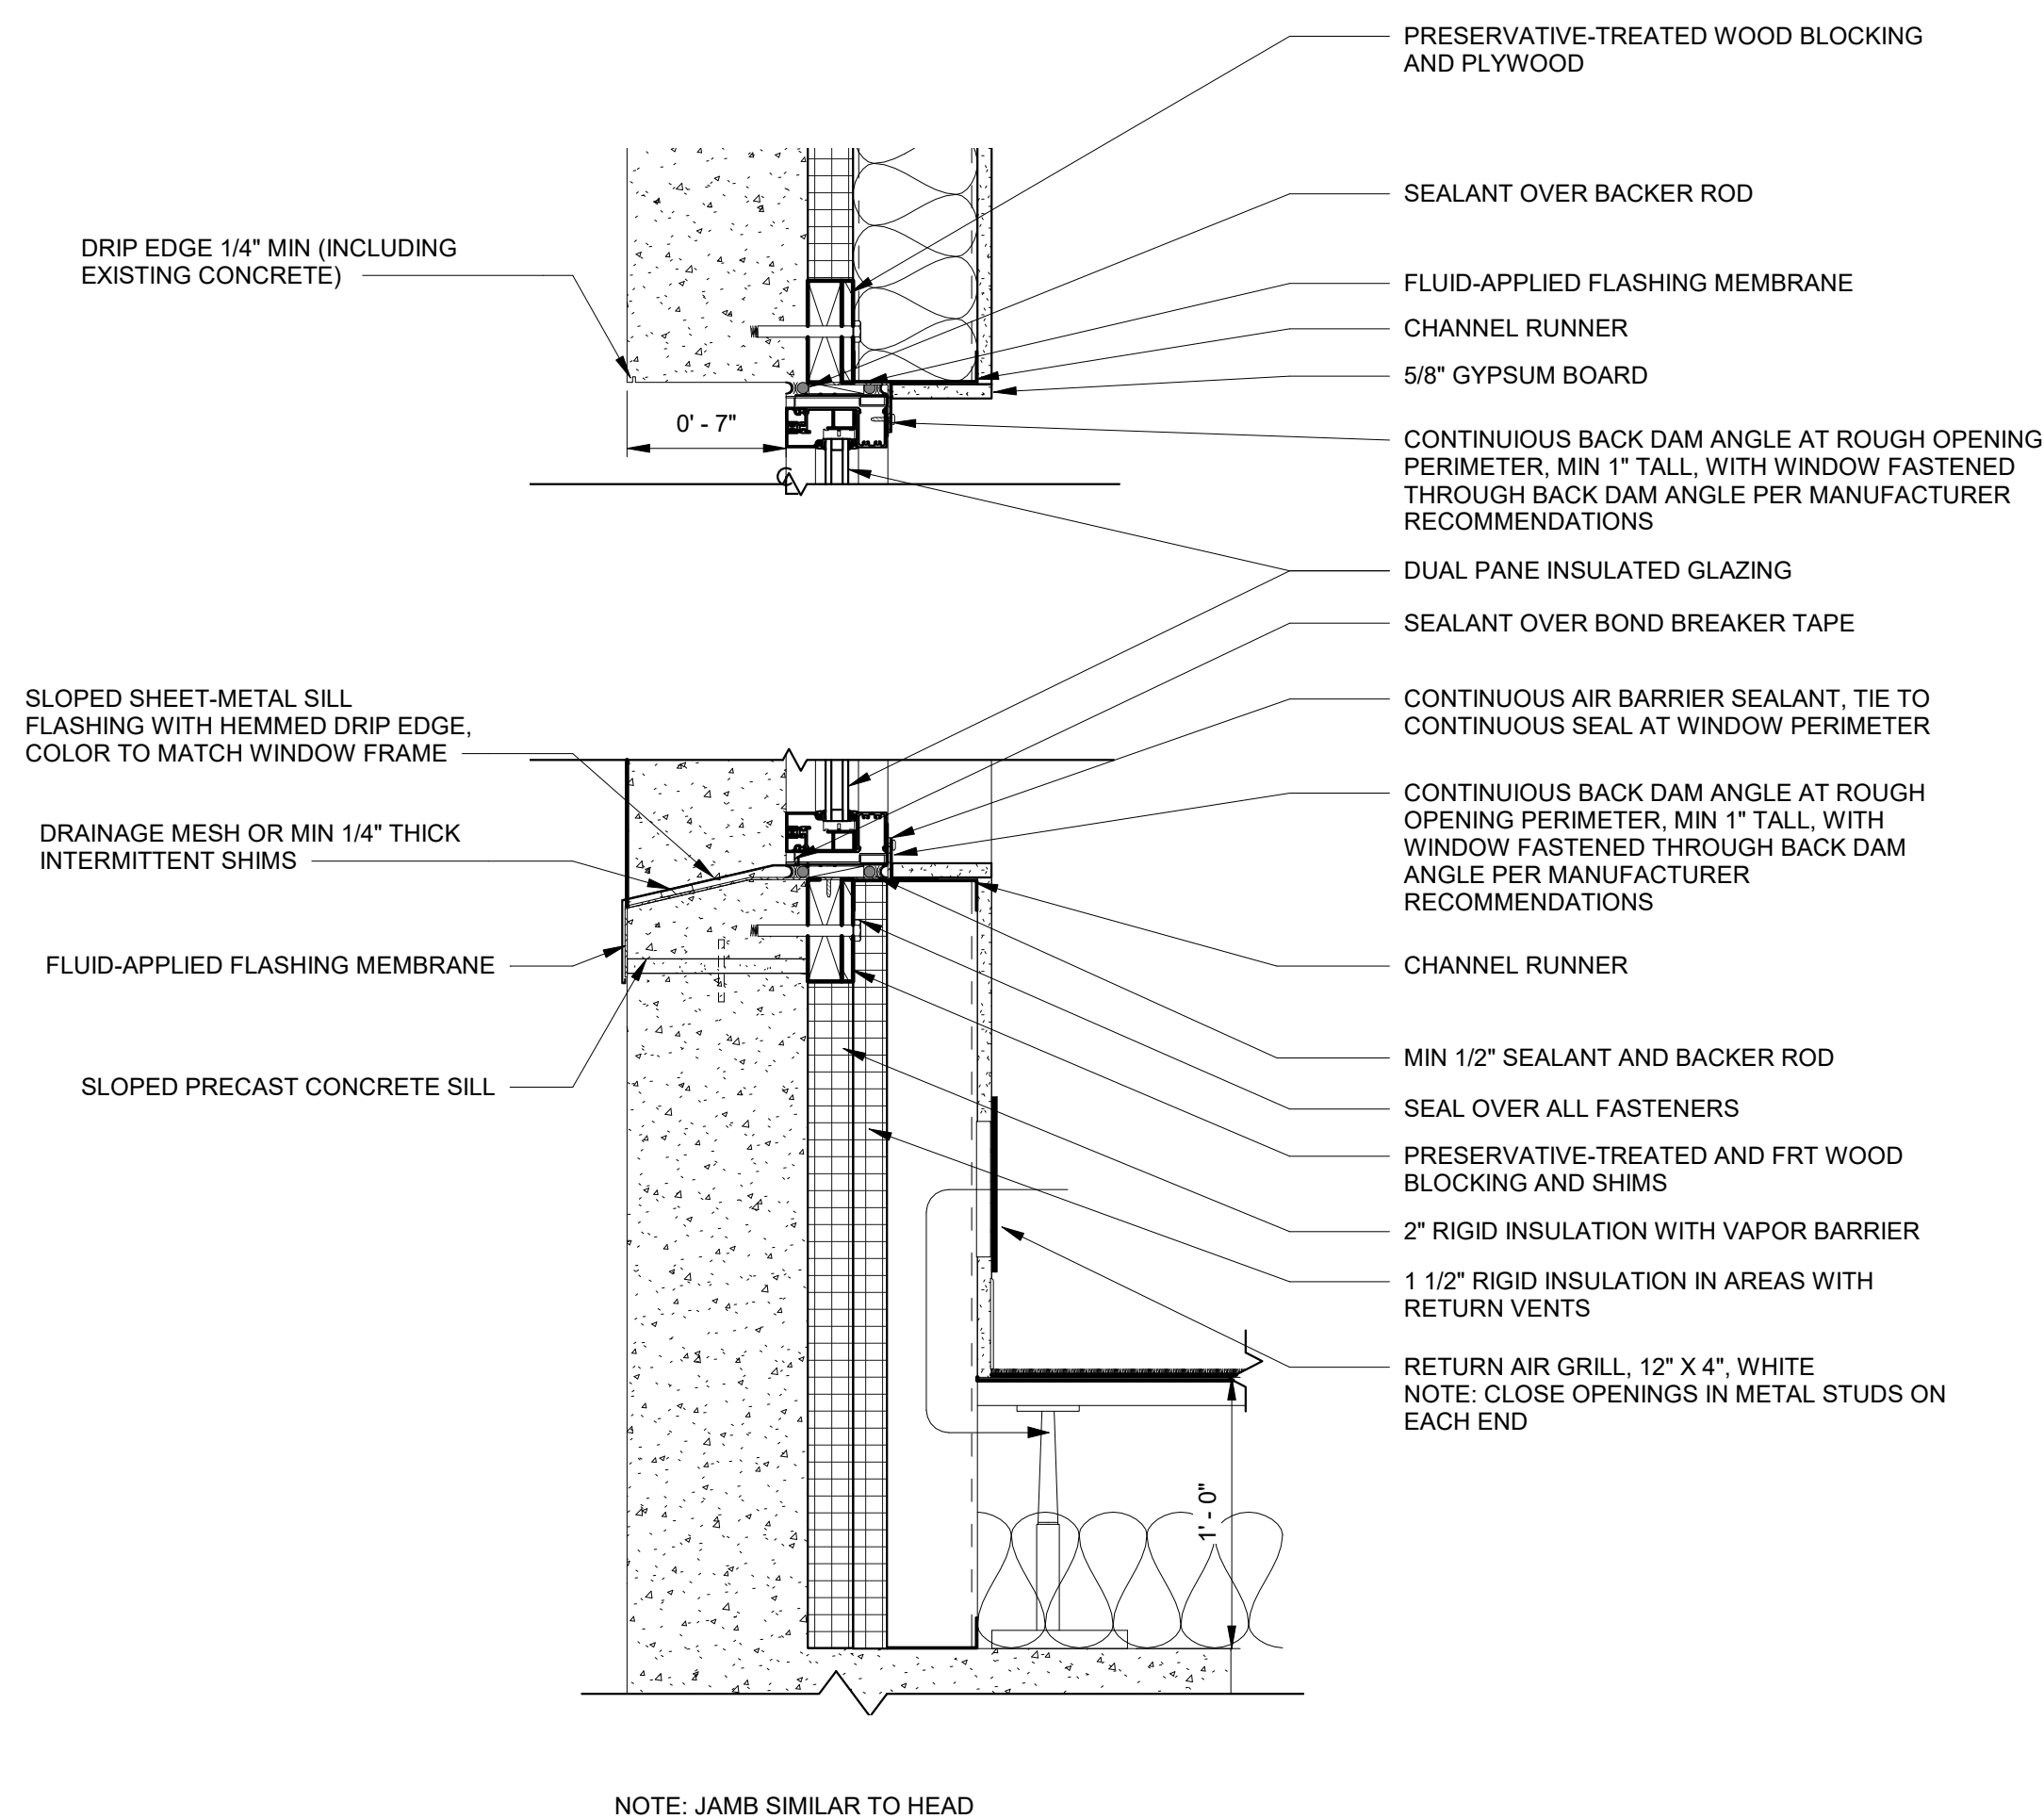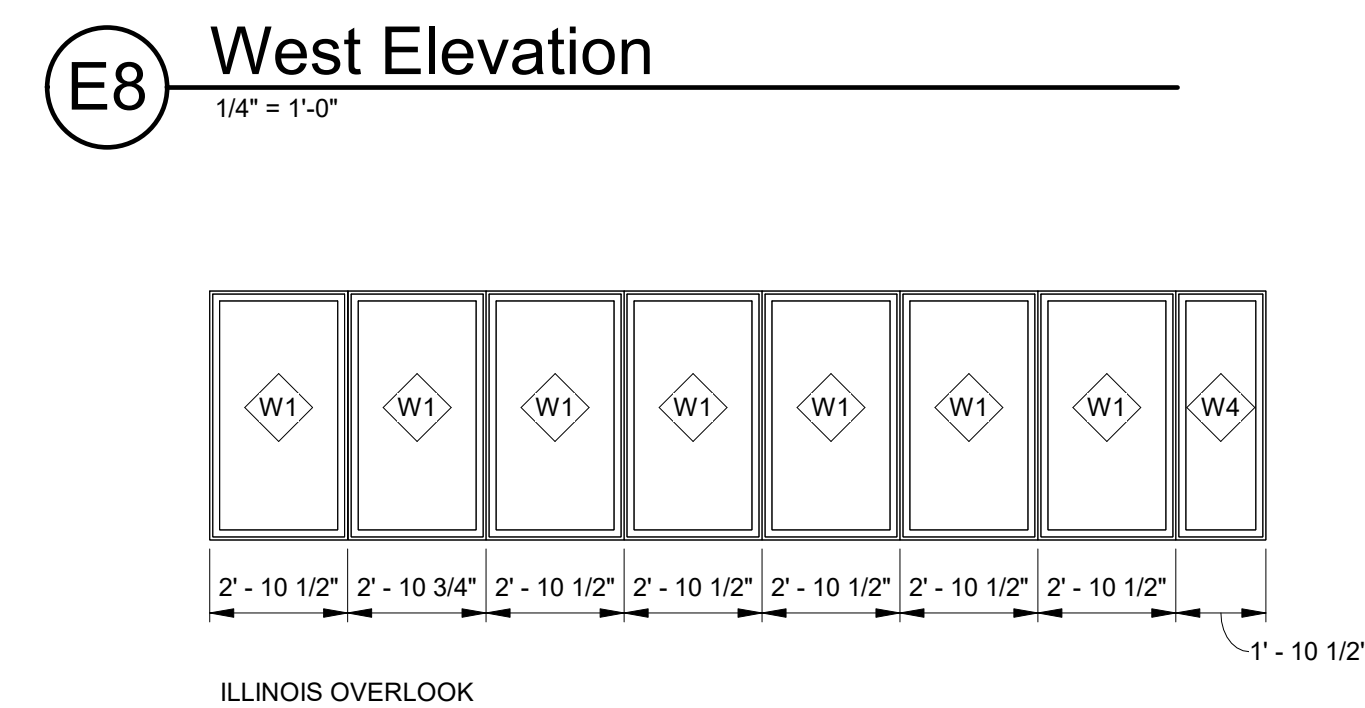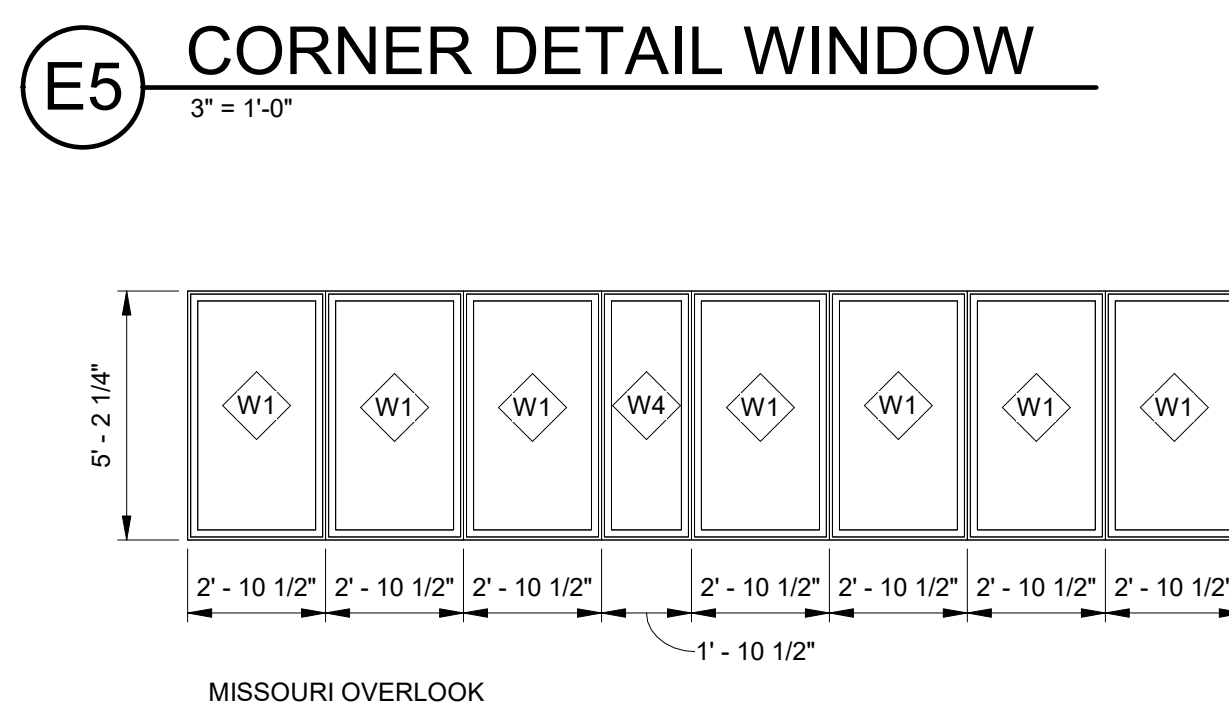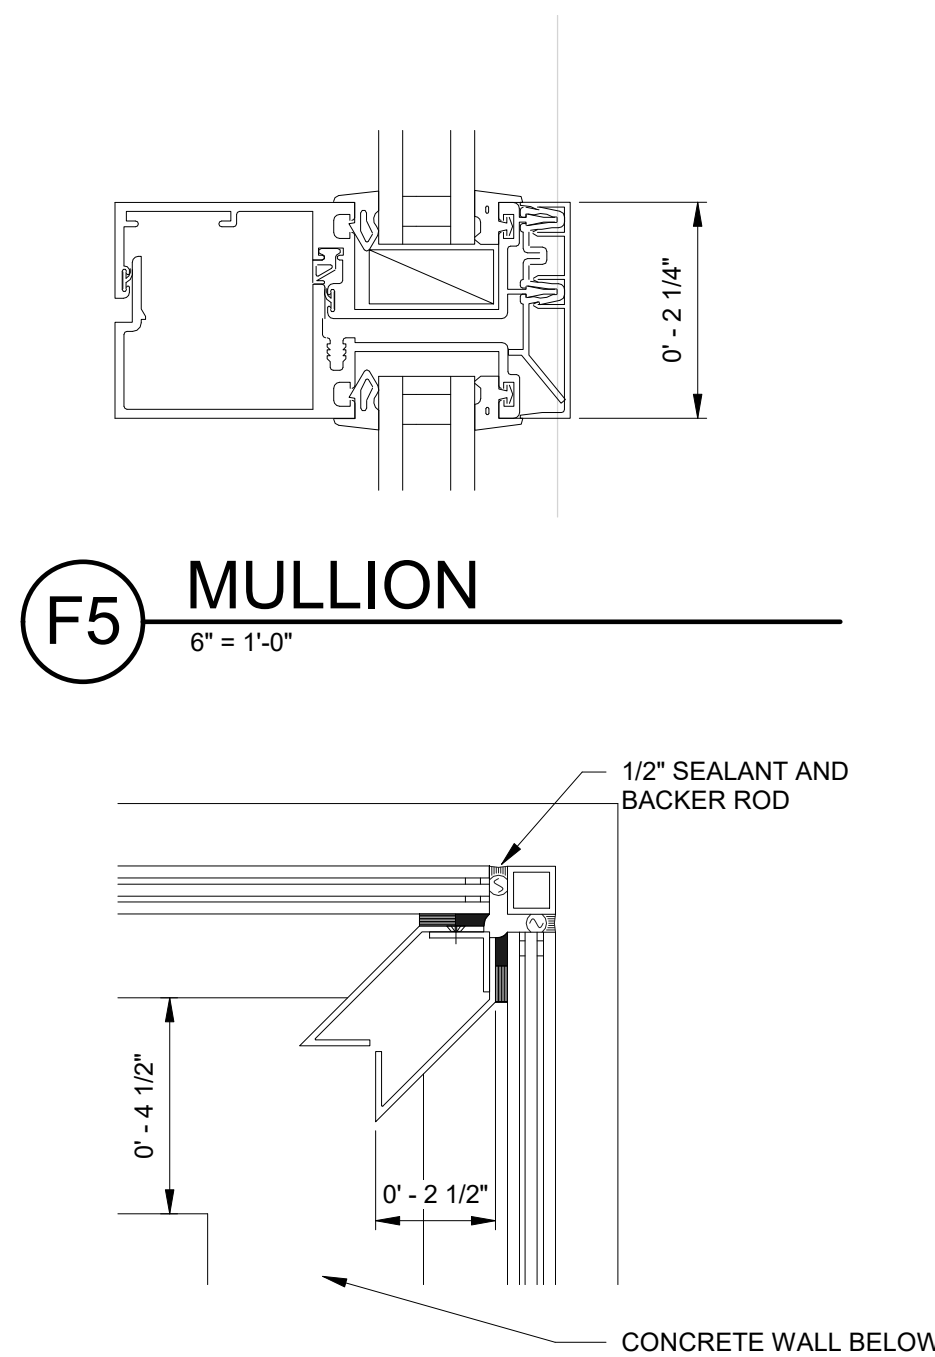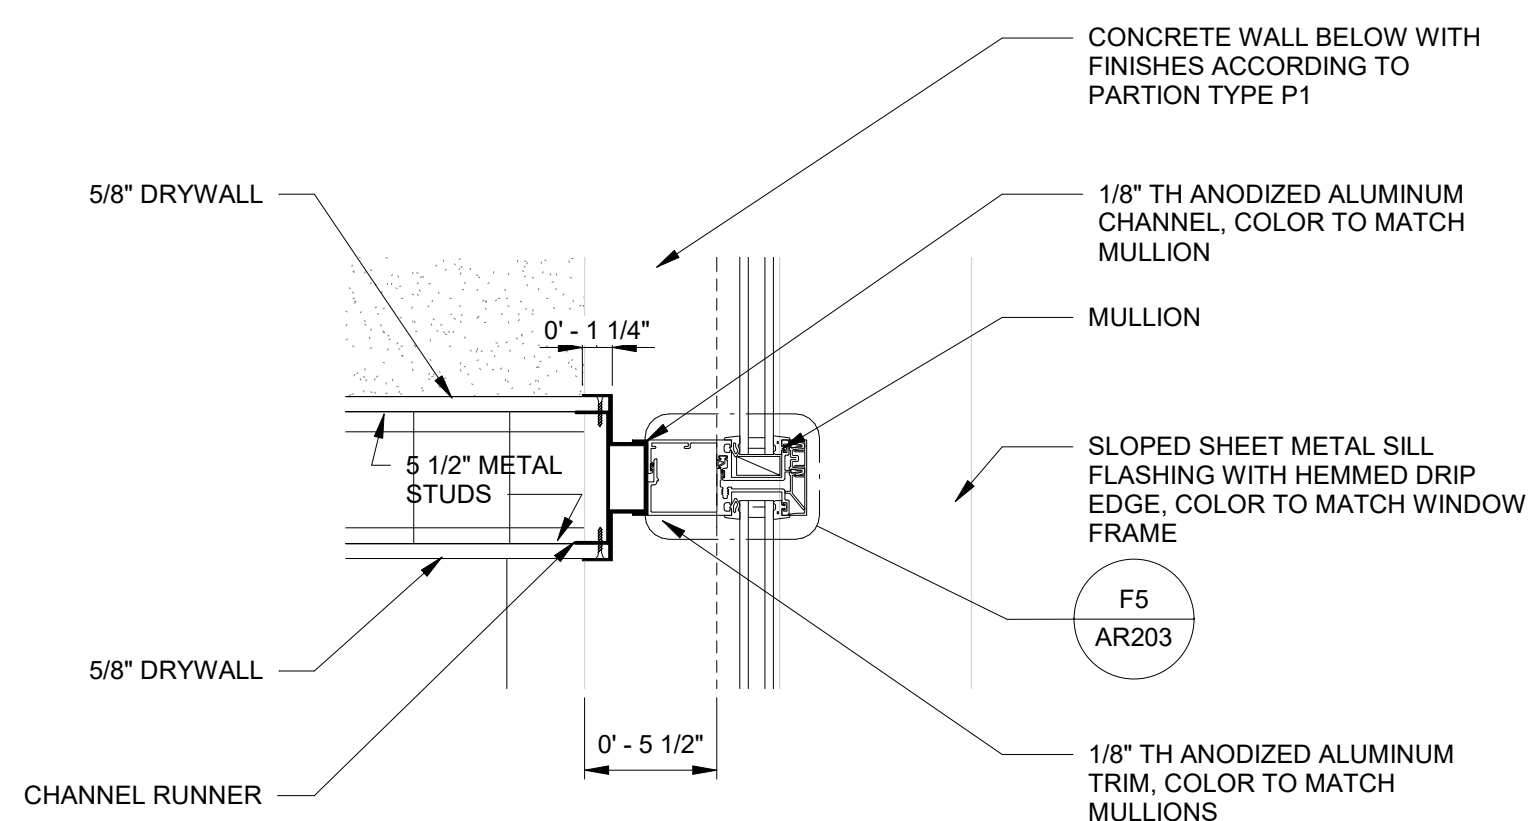
US Army Corps
of Engineers ®[illegible]

US ARMY CORPS OF ENGINEERS ST. LOUIS DISTRICT ST. LOUIS, MISSOURI 63103	DESIGNED BY: MY	ISSUE DATE: MAY 2021
	DRAWN BY: MY	SOLICITATION NO.: W912P9-21-R-0011
	CHECKED BY: P	CONTRACT NO.:
	SUBMITTED BY: SMH	
	SIZE:	


MEL PRICE LOCKS AND DAM
MAIN LOCK OVERLOOK ALTERATIONS
ALTON, ILLINOIS
MISSISSIPPI RIVER

SHEET ID


AR203

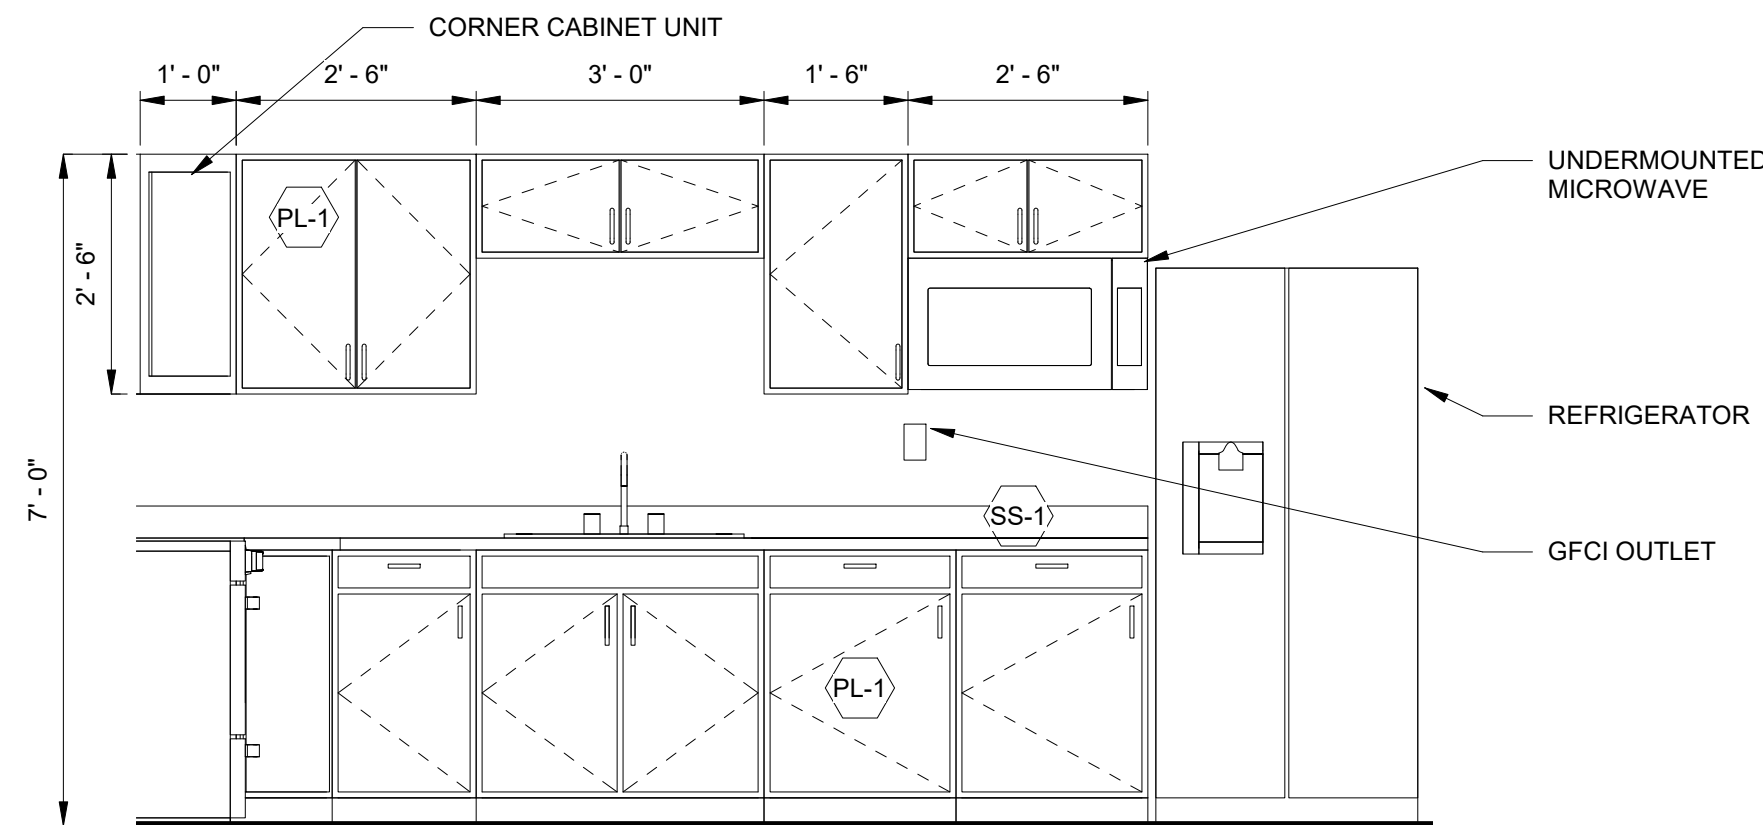


E4 CONTROL ROOM KITCHEN CASEWORK - WEST
1/2" = 1'-0"

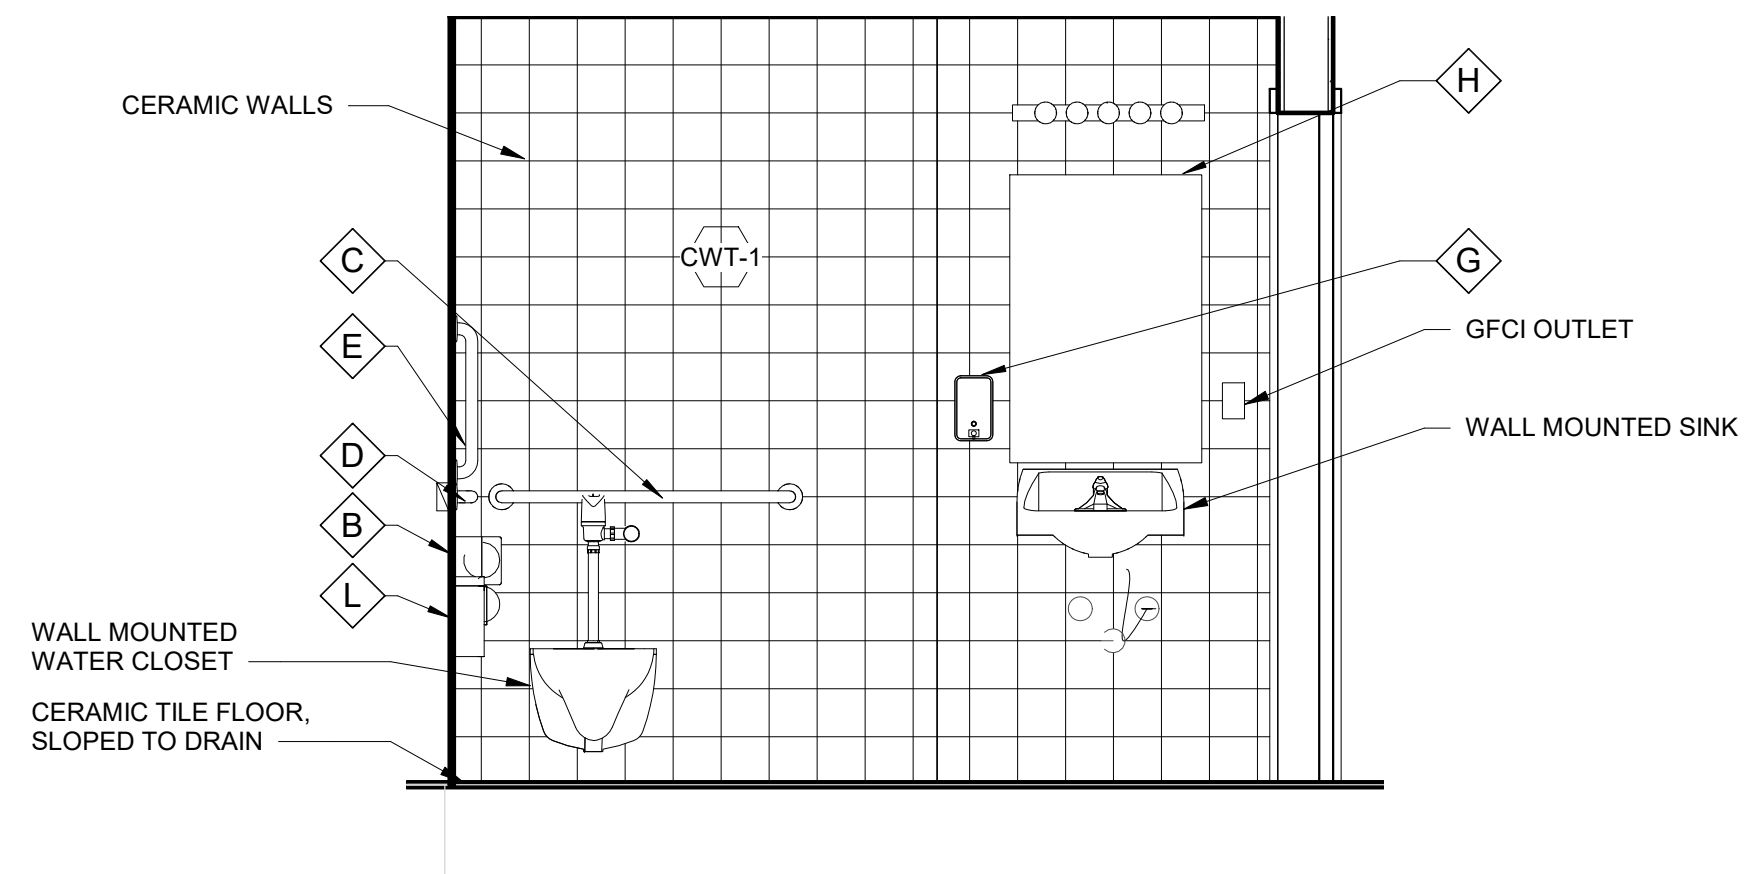

(C4) RESTROOM ELEVATION - NORTH
1/2" = 1'-0"

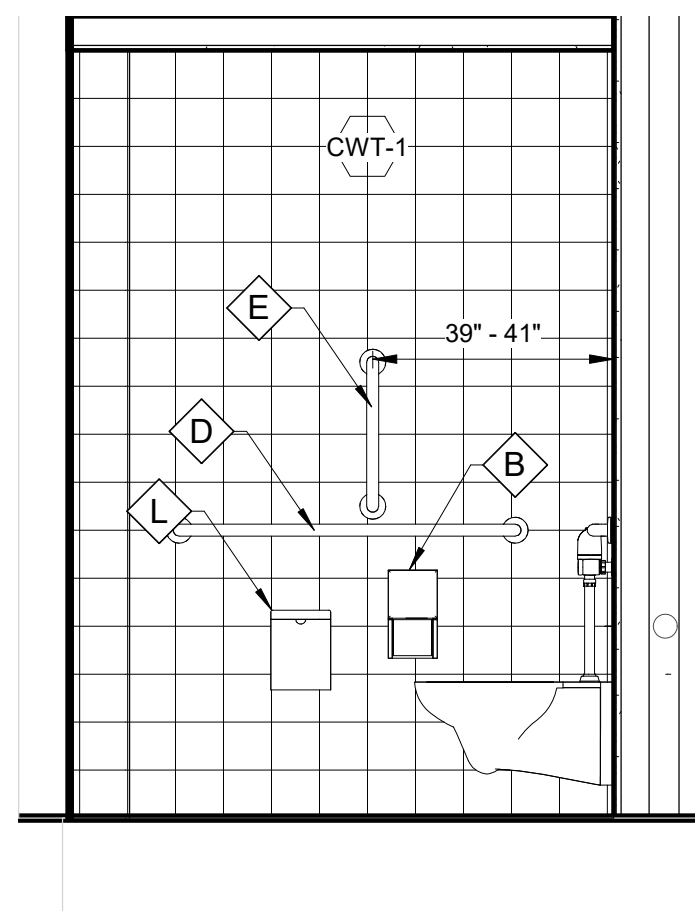

A4 RESTROOM ELEVATION - WEST
1/2" = 1'-0"

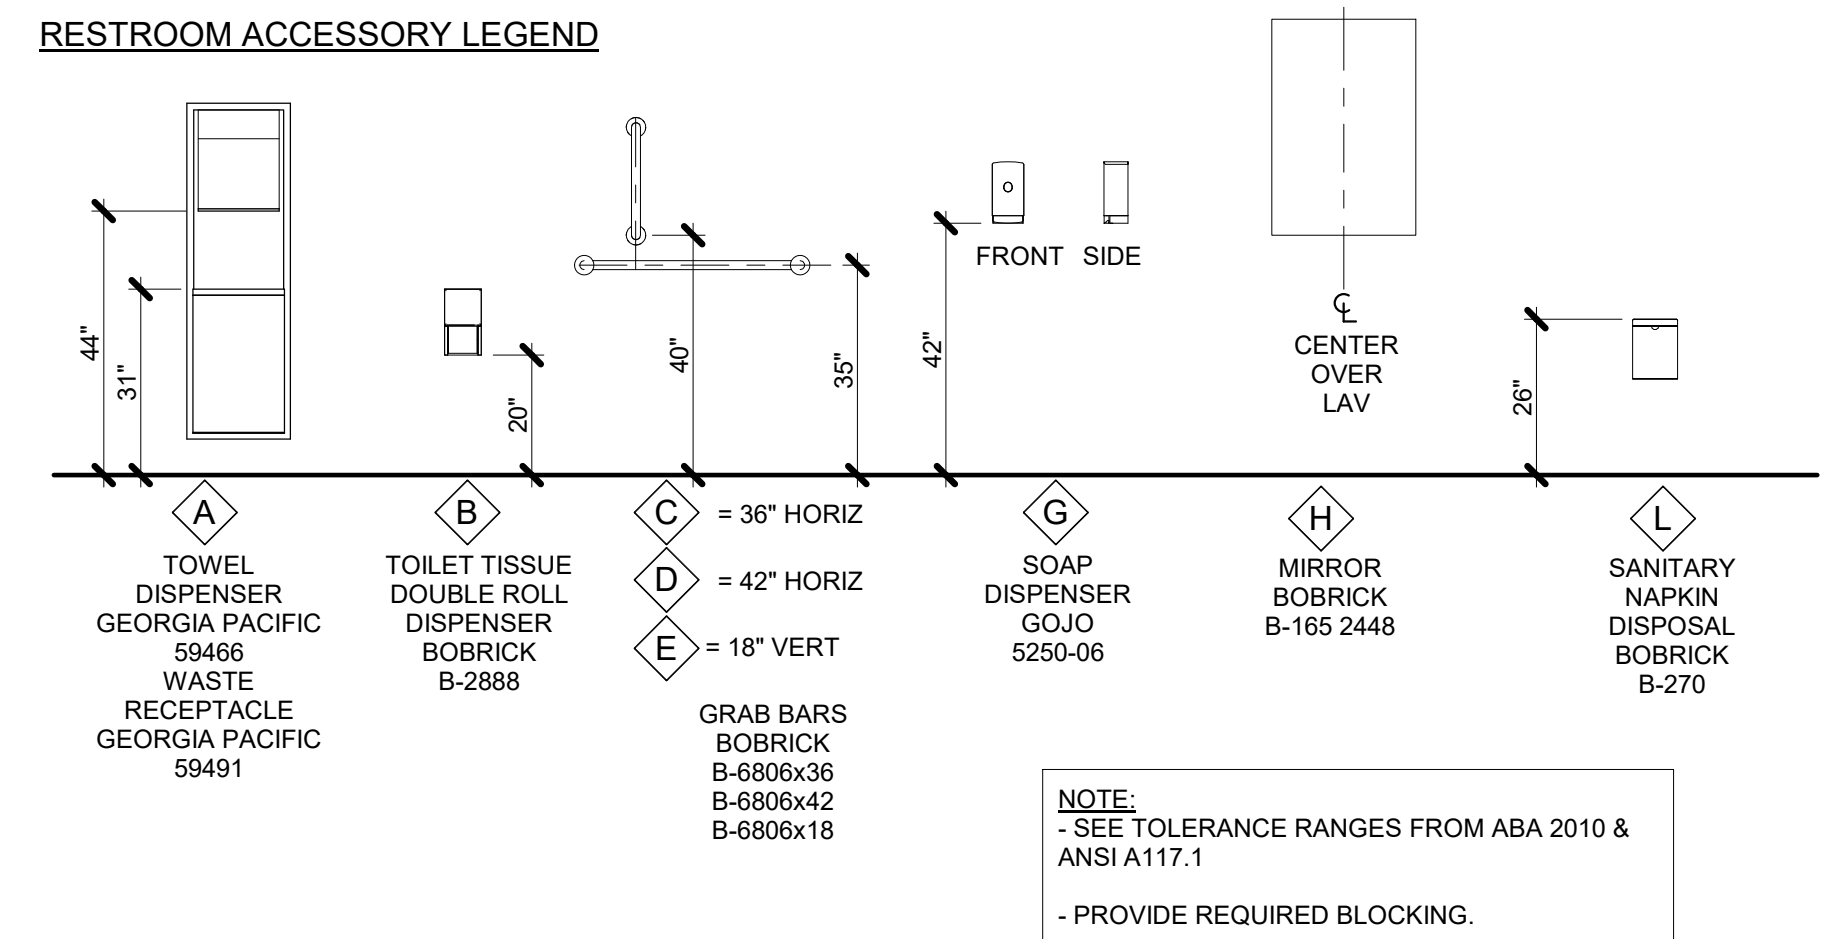

GENERAL SHEET NOTES

HARDWARE BASIS OF DESIGN: AS AMEROCK ALLISON VALUE 3 3/4"
CTC PULL #BP52996G10 SATIN NICK FINISH

SINK BASIS OF DESIGN: UNDERMOUNT ADA DOUBLE SINK AS KOHLER K-RH20062

PROVIDE A UL LISTED RANGE TOP EXTINGUISHER CONNECTED TO THE FACILITY FIRE ALARM SYSTEM FOR SHUT OFF ELECTRIC POWER TO THE STOVE.

PROVIDE A STAINLESS STEEL BOTTOM FREEZER REFRIGERATOR MIN 22 CU. FT.

PROVIDE A 30" STAINLESS STEEL ELECTRIC RANGE WITH MATCHING

DUCTLESS RANGE HOOD ABOVE



**S Army Corps
f Engineers ®**

[illegible]

US ARMY CORPS OF ENGINEERS ST. LOUIS DISTRICT ST. LOUIS, MISSOURI 63103	DRAWN BY: MY		CONTRACT NO.: FA
	CHECKED BY: FA		
	SUBMITTED BY: SMH		CONTRACT NO.: W91299-21-R-0011
	SIZE: ANSI		

MAIN LOCK OVERLOOK ALTERATIONS
ALTON, ILLINOIS
MISSISSIPPI RIVER

SHEET ID

AR204

G

F

E

D

C

B

Material Finish Schedule		Material Finish Schedule	
Basis of Design		Basis of Design	
Code	Item/Specification	Code	Item/Specification
ACT-1	ITEM: ACOUSTICAL CEILING TILE	CWT-2	ITEM: CERAMIC WALL TILE
	BASIS OF DESIGN STYLE: AS USG		BASIS OF DESIGN: AS INTERCERAMIC
	TEXTURE: RADAR CLIMAPLUS		STYLE: EMMA
	COLOR: WHITE		COLOR: GRAY
	DIMENSIONS: 2' X 2' X 5/8"		DIMENSIONS: 6" X 6"
	EDGE: SLT		BODY: GLAZED CERAMIC
	FIRE RATING: CLASS A		INSTALLATION: 2 ROWS, 5' HIGH
	NRC: .55		BASIS OF DESIGN GROUT: AS MAPEI
CAC: 35	TYPE: KERAPOXY CQ		
GRID: 15/16", WHITE	COLOR: 02 PEWTER		
CPT-1	ITEM: CARPET TILE		GROUTH WIDTH: 1/8"
	BASIS OF DESIGN STYLE: AS PATCRAFT	P-1	ITEM: PAINT
	STYLE: 10379 ORBITAL		BASIS OF DESIGN MFR: AS SHERWIN WILLIAMS
	COLOR: 00370 BOOMERANG		FINISH: FLAT FOR CEILINGS, EGGSHELL FOR WALLS
	DIMENSIONS: 24" X 24"		COLOR: SW 7005 PURE WHITE
	CONSTRUCTION: MULTE-LEVEL PATTERN LOOP	P-2	ITEM: PAINT
	FIBER TYPE: SOLUTION DYED NYLON		BASIS OF DESIGN MFR: AS SHERWIN WILLIAMS
	TUFTED YARN FACE WEIGHT: 14 OZ/SY		FINISH: EGGSHELL FOR WALLS
DYE METHOD: 100% SOLUTION DYED	COLOR: SW 6204 SEA SALT		
GAUGE: 1/10	P-3	ITEM: PAINT	
TUFTED PILE HEIGHT: 6/32" HIGH / 3/32" LOW		BASIS OF DESIGN MFR: AS PPG	
STITCHES PER INCH: 10.2		FINISH: SEMI-GLOSS FOR HM DOORS AND DOOR TRIM	
FINISH: SOIL PROTECTION		COLOR: PPG1007-6 CHARCOAL	
TRAFFIC CLASS: HEAVY (TARR)	T-1	ITEM: FLOORING TRANSITION TRIM	
INSTALLATION METHOD: MONOLITHIC		BASIS OF DESIGN MFR: AS JOHNSONITE	
CT-1		ITEM: PORCELIN FLOOR TILE	TYPE: EDGE PROTECTION, ROLLING TRAFFIC
		BASIS OF DESIGN: AS INTERCERAMIC	MATERIAL: VINYL
	STYLE: CONSTRUCT	APPLICATION: AS APPROPRIATE	
	COLOR: SILVER TEMPEST	COLOR: 20 CHARCOAL	
	DIMENSIONS: 12" X 24"	VB-1	ITEM: VINYL BASE
	BODY: DURATEC GLAZED		BASIS OF DESIGN MFR: AS JOHNSONITE
	TRIM: 6" X 12" COVE BASE, 1" X 6" COVE BASE CORNER		COLOR: 20 CHARCOAL
	BASIS OF DESIGN GROUT: AS MAPEI		HEIGHT: 4"
TYPE: KERAPOXY CQ		TYPE: STRAIGHT FOR CARPET, TOE FOR HARD SURFACE	
COLOR: 02 PEWTER		THICKNESS: 1/8"	
GROUTH WIDTH: 1/8"	VCT-1	ITEM: VINYL COMPOSITION TILE	
CWT-1	ITEM: CERAMIC WALL TILE		BASIS OF DESIGN MFR: AS ARMSTRONG
	BASIS OF DESIGN: AS INTERCERAMIC		STYLE: IMPERIAL TEXTURE STANDARD EXCELON
	STYLE: EMMA		COLOR: S1915 CHARCOAL
	COLOR: GRAY		DIMENSIONS: 12" X 12" X 1/8" THICK
	DIMENSIONS: 6" X 6"	PL-1	ITEM: PLASTIC LAMINATE
	BODY: GLAZED CERAMIC		BASIS OF DESIGN STYLE: AS WILSONART
	INSTALLATION: STACKED		COLOR: SLATE GREY D91-60
	BASIS OF DESIGN GROUT: AS MAPEI		FINISH: MATTE
TYPE: KERAPOXY CQ		APPLICATION: VERTICAL	
COLOR: 02 PEWTER	SS-1	ITEM: SOLID SURFACE	
GROUTH WIDTH: 1/8"		BASIS OF DESIGN: AS CORIAN	
		COLOR: SANDSTONE	
		THICKNESS: 1/2"	
		GROUP: B	
		FINISH: SEMI-CLOSS	
		EDGE: EASED	

HARDWARE SCHEDULE	
Set 1	
Doors:	101
3	Hinge (Heavy Weight) A8111 4-1/2" x 4-1/2" US26D
1	Office Lock F04 (70 74 SG 8205 LNL) US32D SA
SA	1 Cylinder SFIC - type as required for lock 626
1	Door Closer Reg C02011 PT4H-BF/PT4D AL
1	Wall Stop L02251 US32D
3	Silencer - Metal Frame Type
Set 2	
Doors:	102
3	Hinge (Heavy Weight) A8111 4-1/2" x 4-1/2" US26D
1	Storeroom Lock F07 (70 74 SG 8206 LNL) US32D SA
SA	1 Cylinder SFIC - type as required for lock 626
1	Door Closer Reg C02011 PT4H-BF/PT4D AL
1	Wall Stop L02251 US32D
3	Silencer - Metal Frame Type
Set 3	
Doors:	103
3	Hinge (Heavy Weight) A8111 4-1/2" x 4-1/2" US26D
1	Privacy Lock 22 (70 74 SG 8265 LNL) US32D SA
SA	1 Cylinder SFIC - type as required for lock 626
1	Door Closer Reg C02011 PT4H-BF/PT4D AL
1	Wall Stop L02251 US32D
3	Silencer - Metal Frame Type



**US Army Corps
of Engineers®**

[illegible]

US ARMY CORPS OF ENGINEERS ST. LOUIS DISTRICT ST. LOUIS, MISSOURI 63103	DESIGNED BY:		ISSUE DATE:
	MY	BY	MAY 2021
	BY	BY	
	BY	BY	
ST. LOUIS, MISSOURI 63103	CHECKED BY:		CONTRACT NO.:
	FA	BY	9601592412R00011
	SUBMITTED BY:		
	BY		
STANDARD		ANSI D	

MEL PRICE LOCKS AND DAM
MAIN LOCK OVERLOOK ALTERATIONS
ALTON, ILLINOIS
MISSISSIPPI RIVER
MATERIAL FINISH AND HARDWARE SCHEDULE

SHEET ID

AR205


[illegible]

US ARMY CORPS OF ENGINEERS ST. LOUIS DISTRICT ST. LOUIS, MISSOURI 63103	DRAWN BY: MY	SOLICITATION NO.: W912P9-21-R-0011	DATE ORDERED BY: MAY 2021
	CHECKED BY:	CONTRACT NO.:	
	FURNISHED BY:		
	SIZE:		
	ANSI D		


MEL PRICE LOCKS AND DAM MAIN LOCK OVERLOOK ALTERATIONS ALTON, ILLINOIS MISSISSIPPI RIVER

SHEET ID


AR206

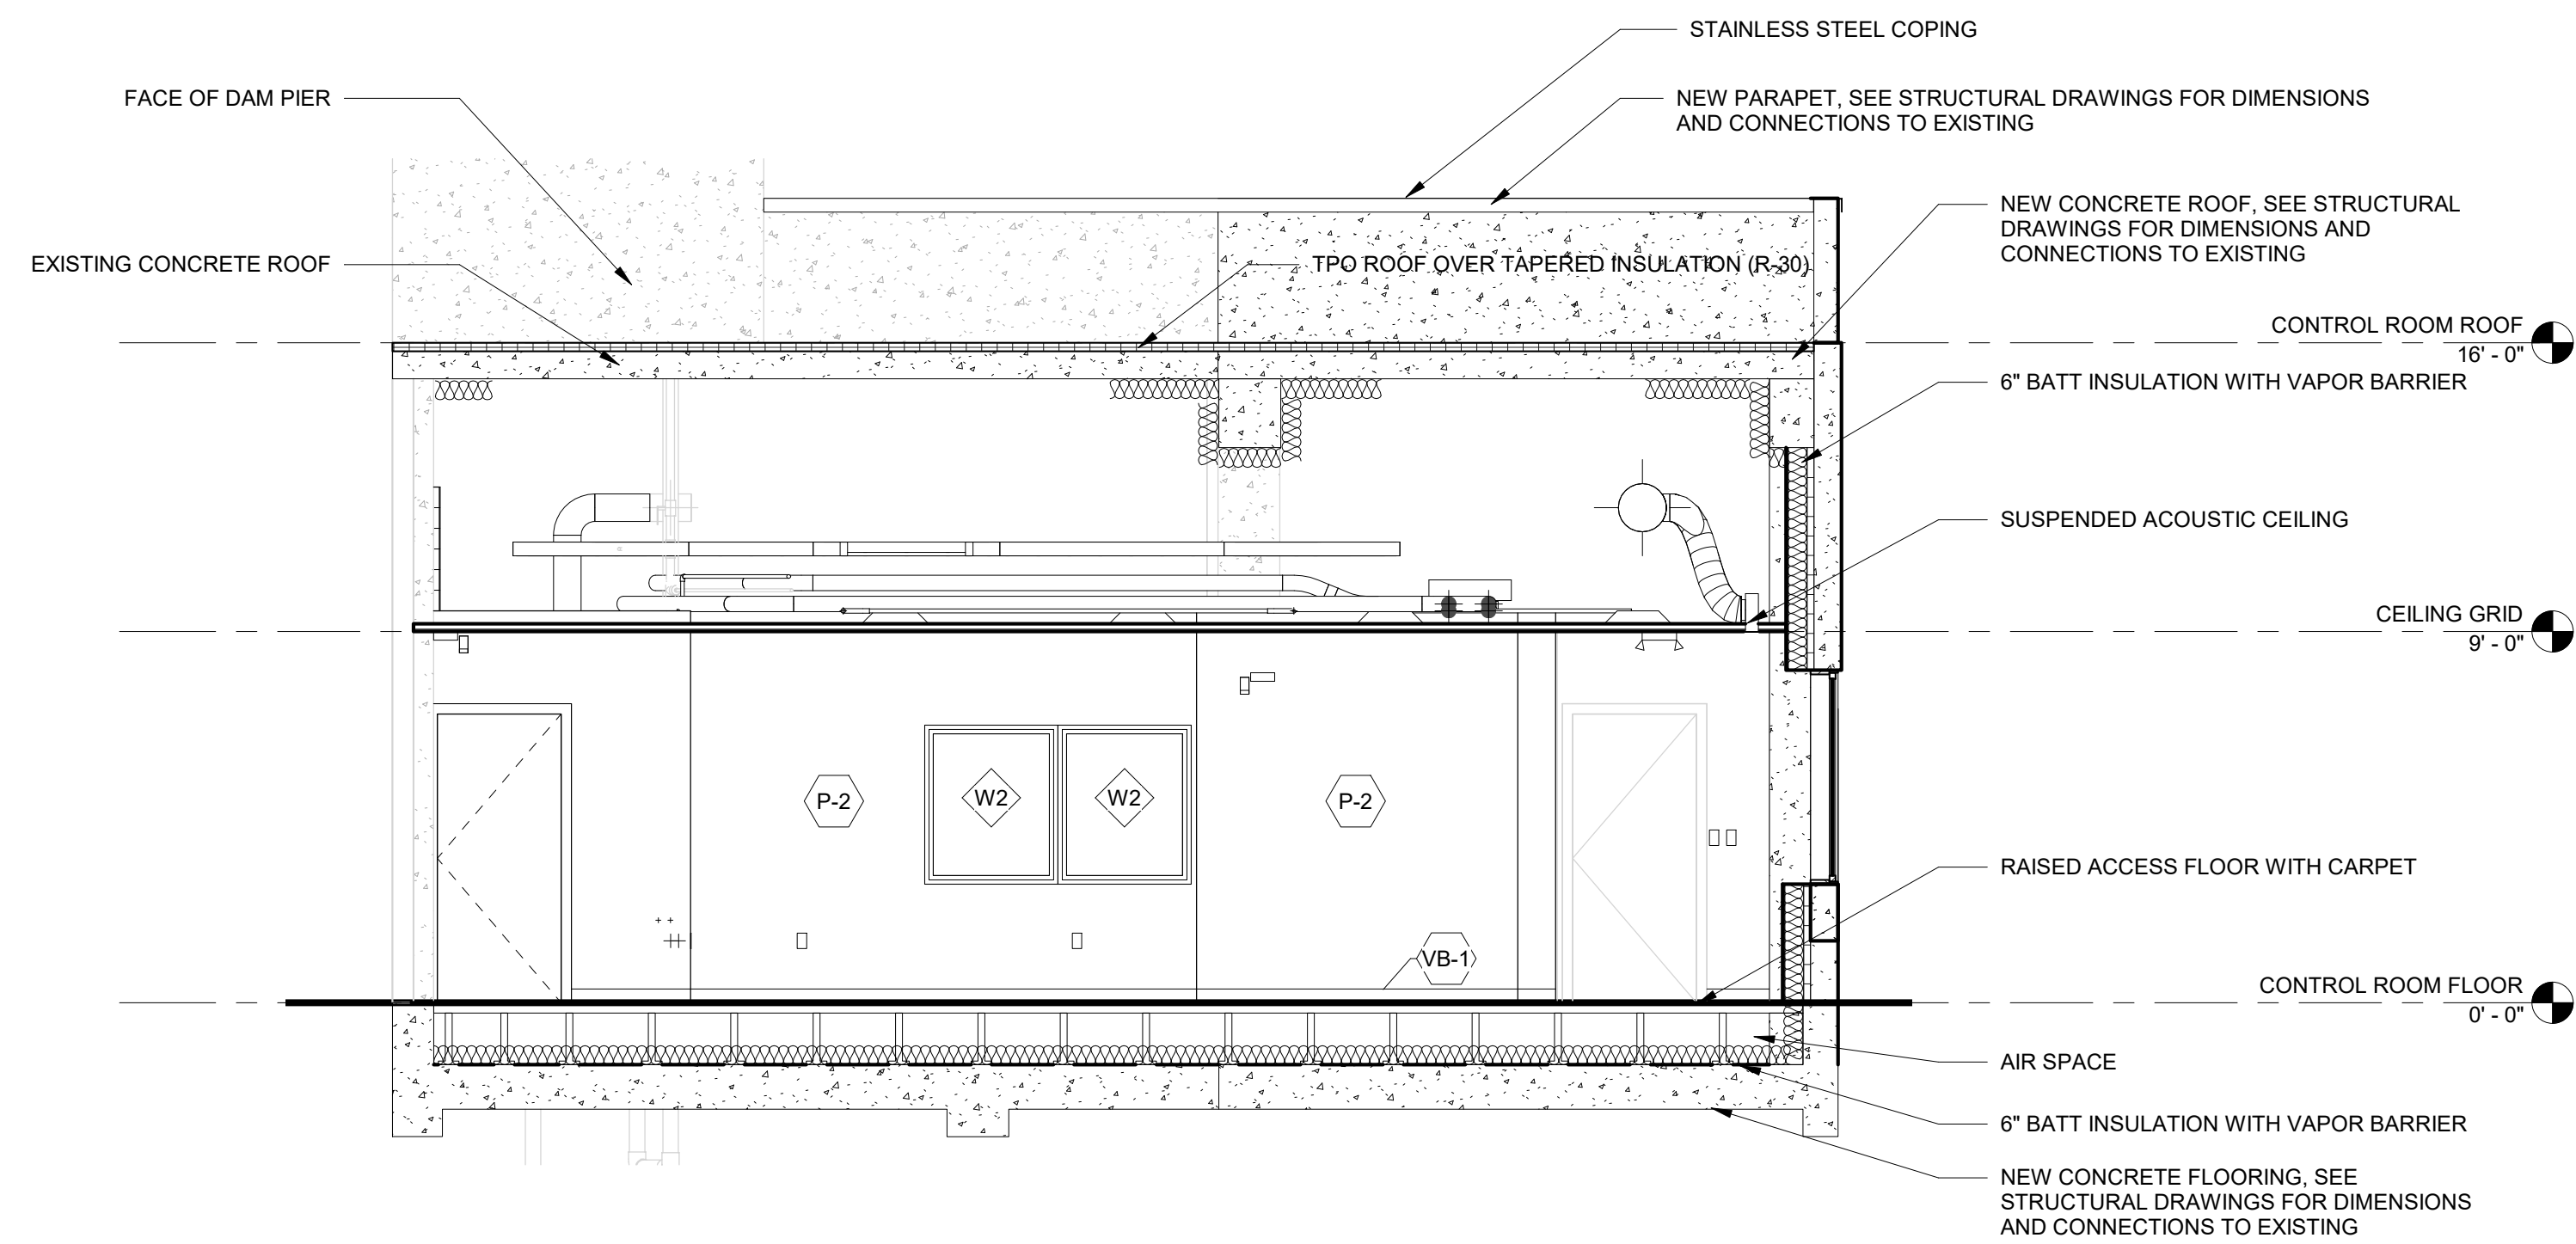


D1 SECTION - VIEWING WEST
1/4" = 1'-0"

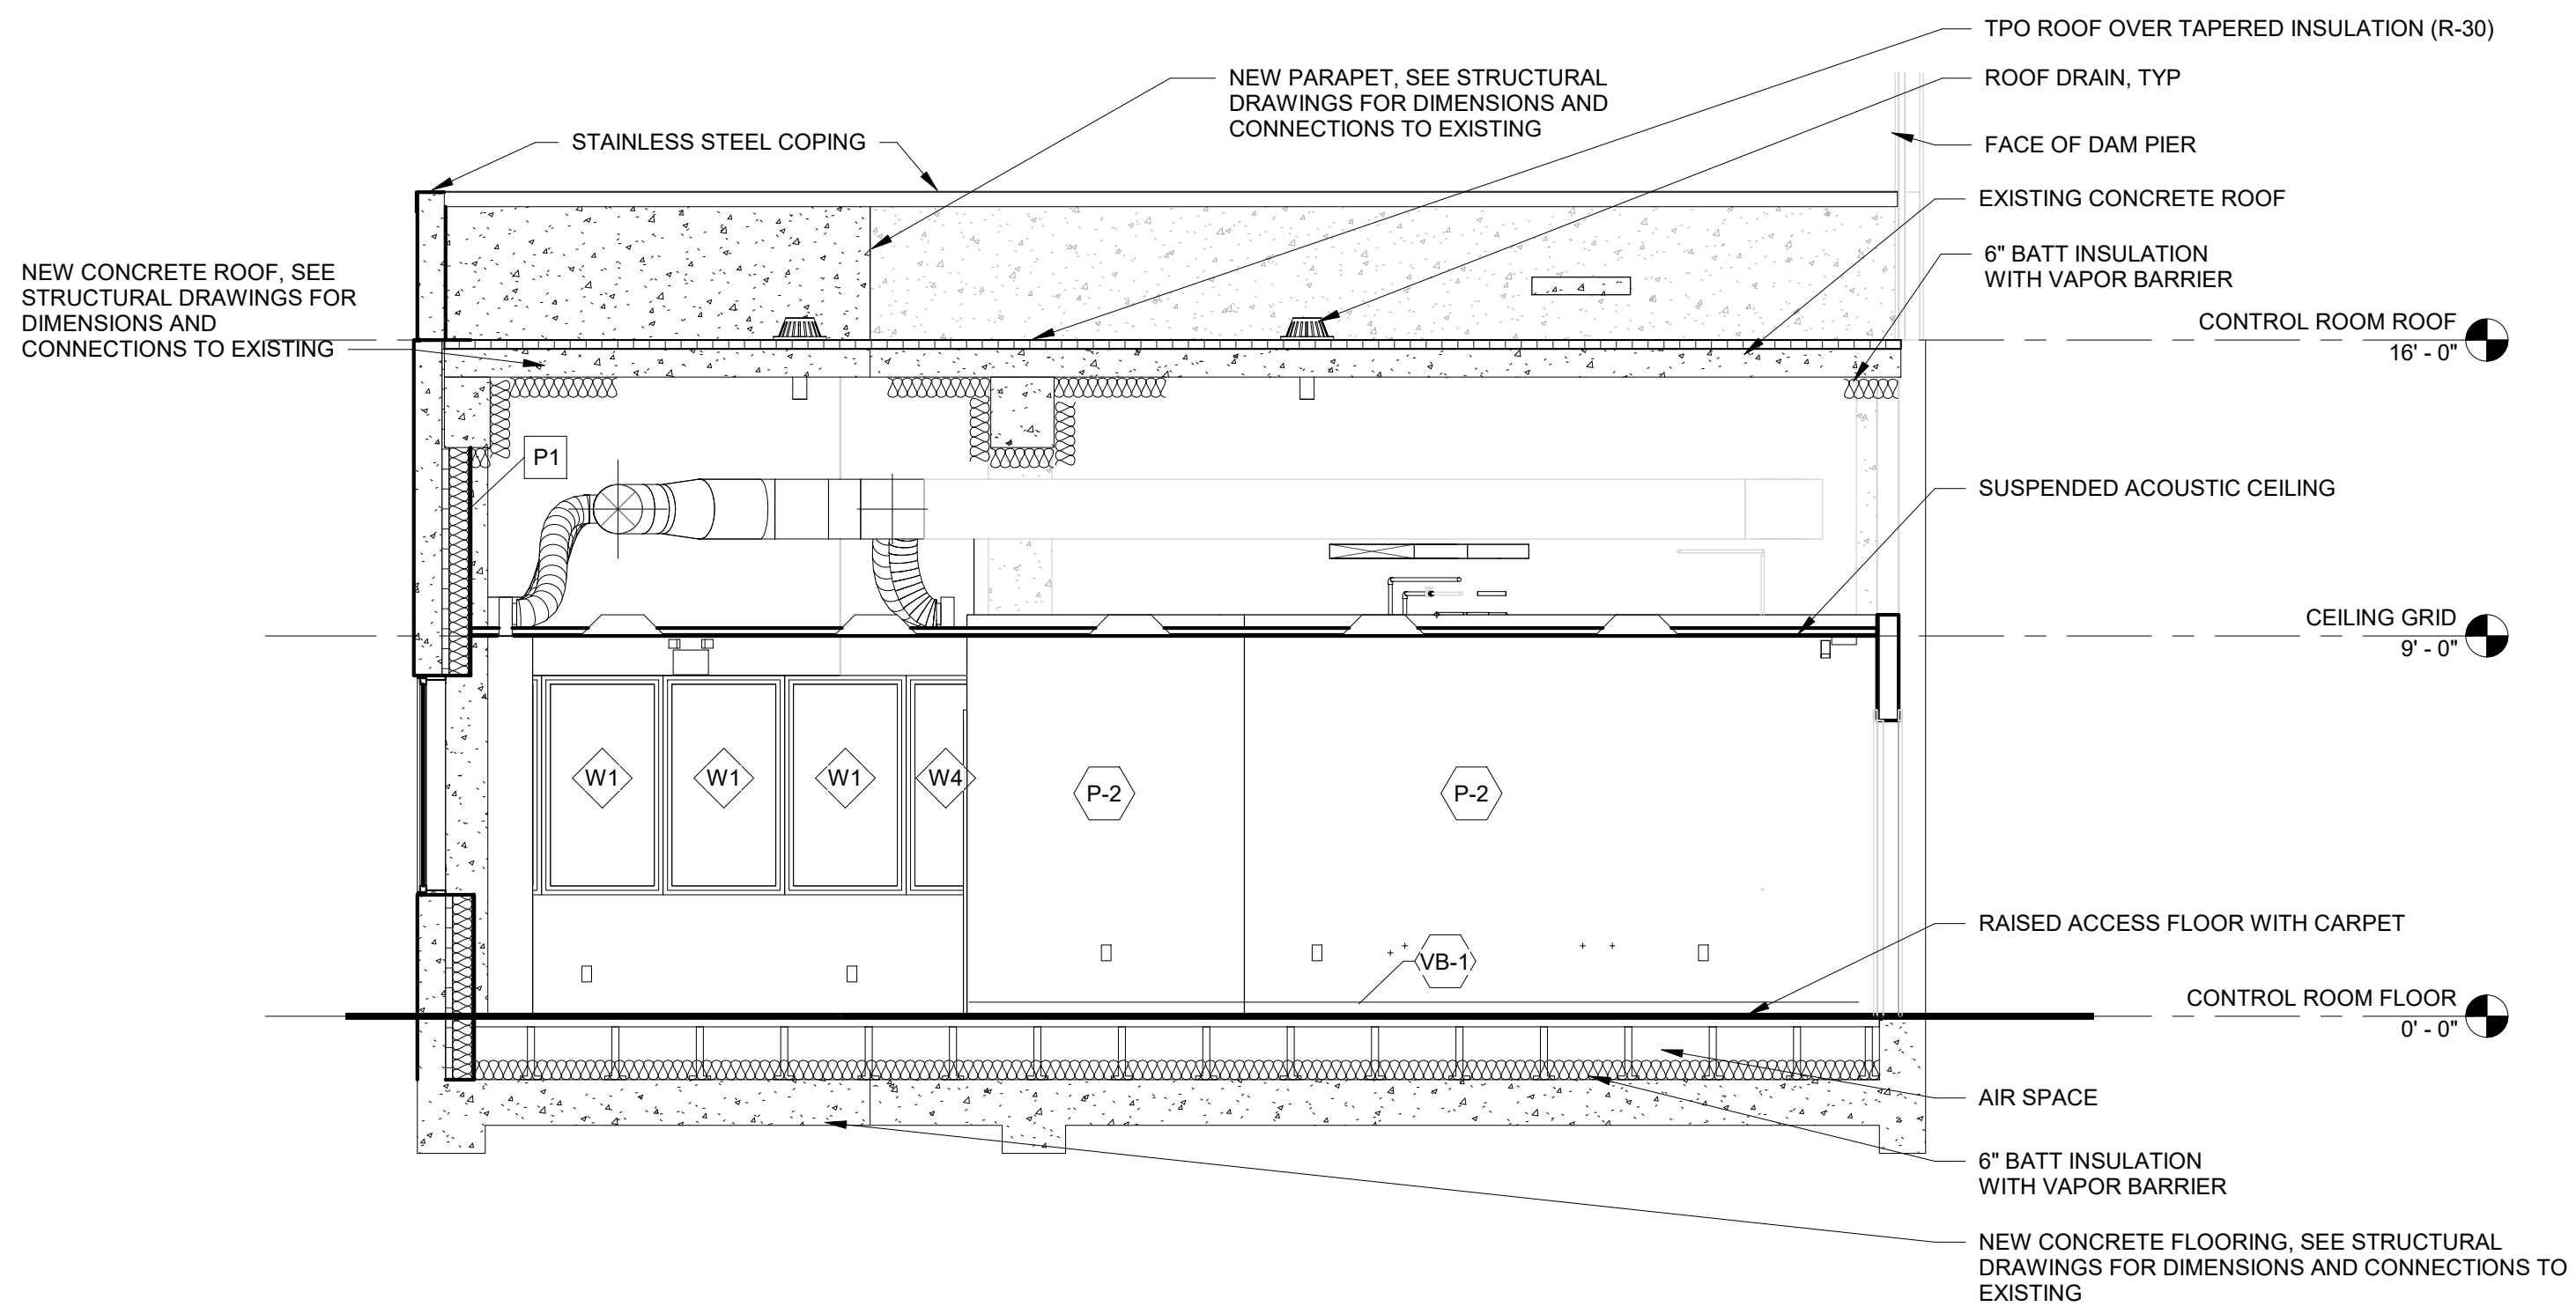


A1 SECTION - VIEWING EAST
1/4" = 1'-0"

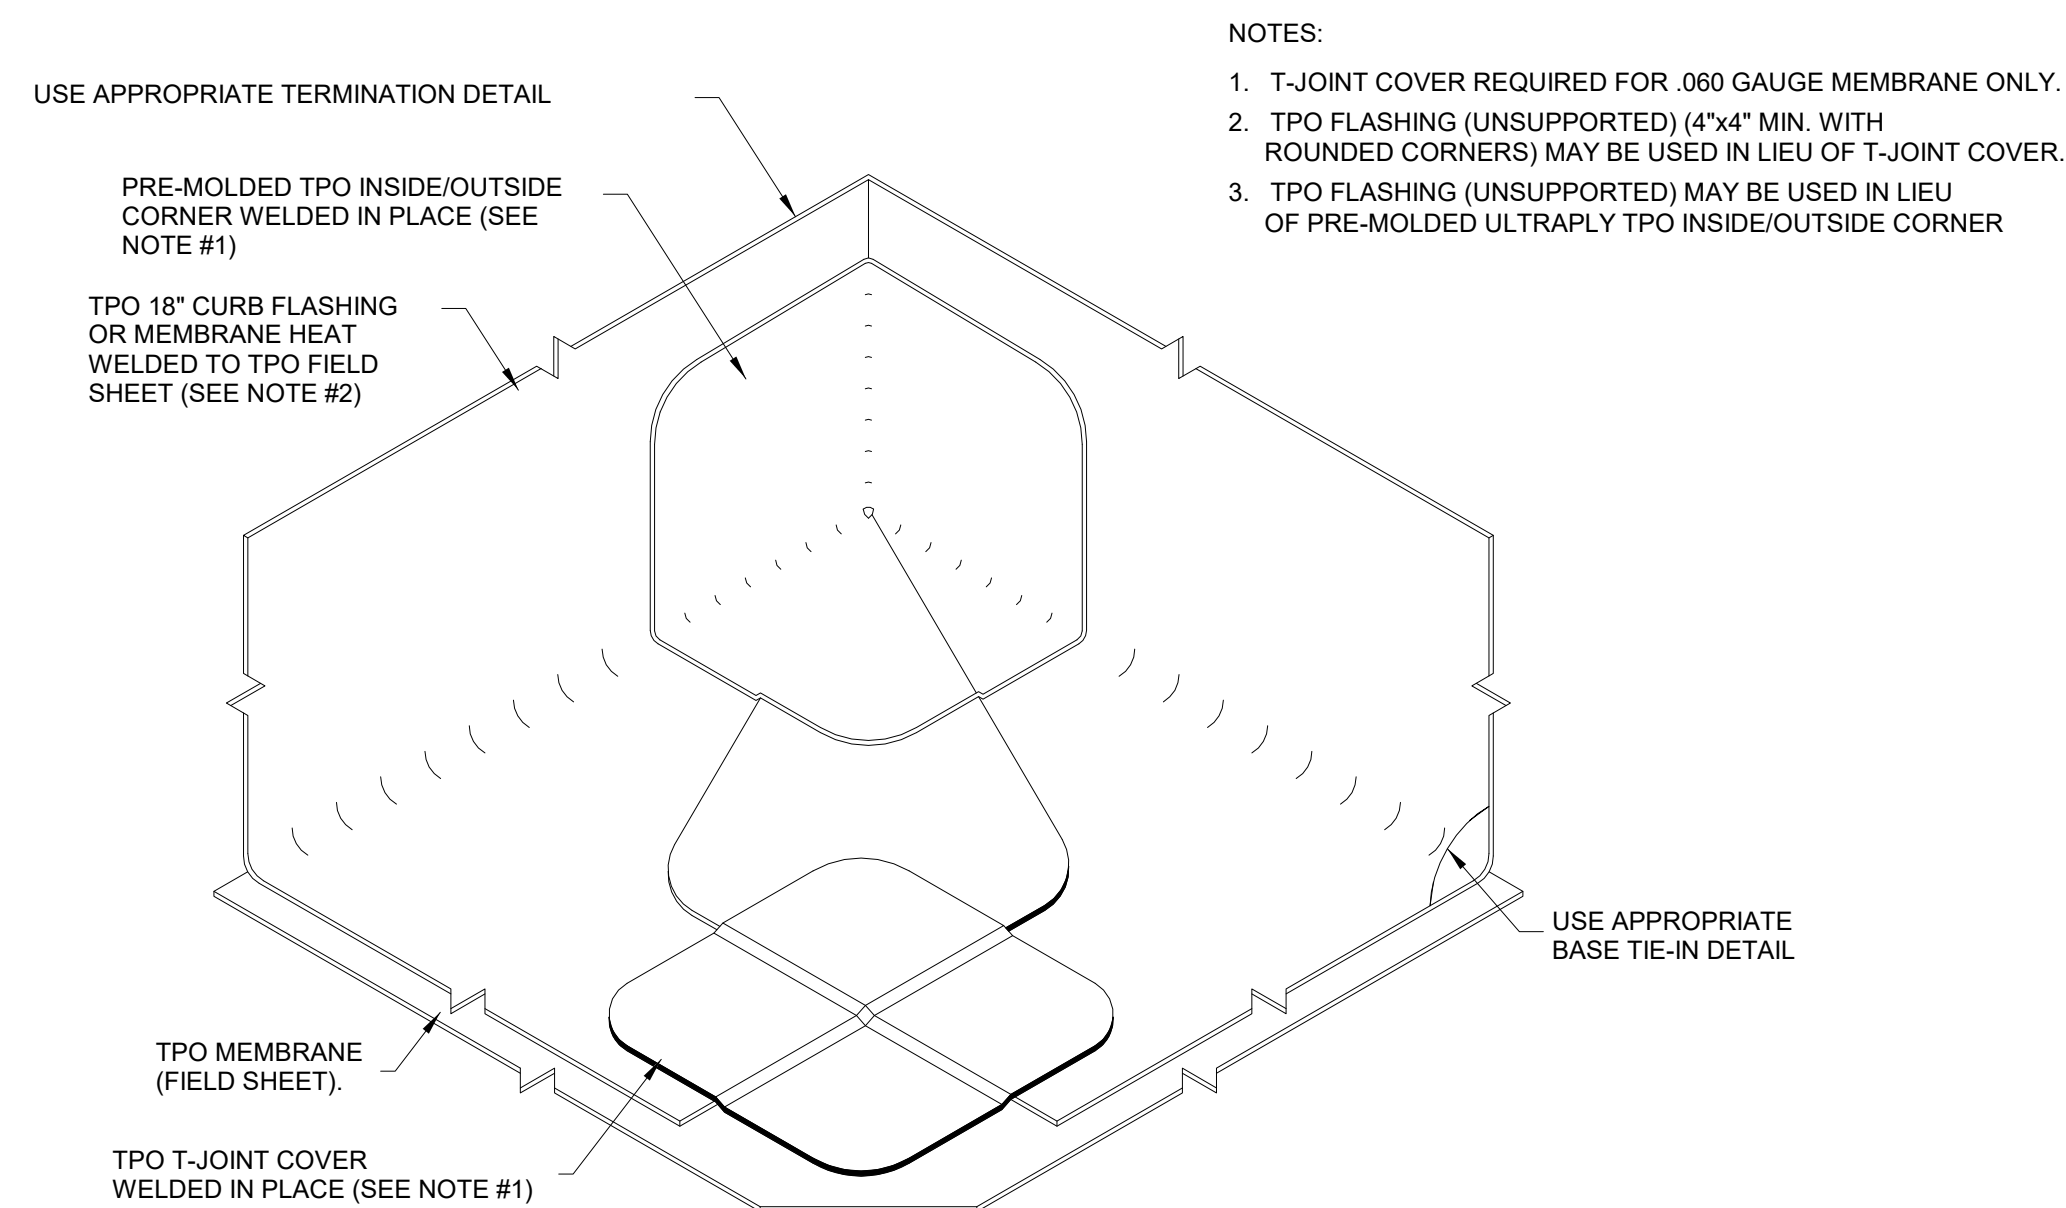


E1 CORNER DETAILS

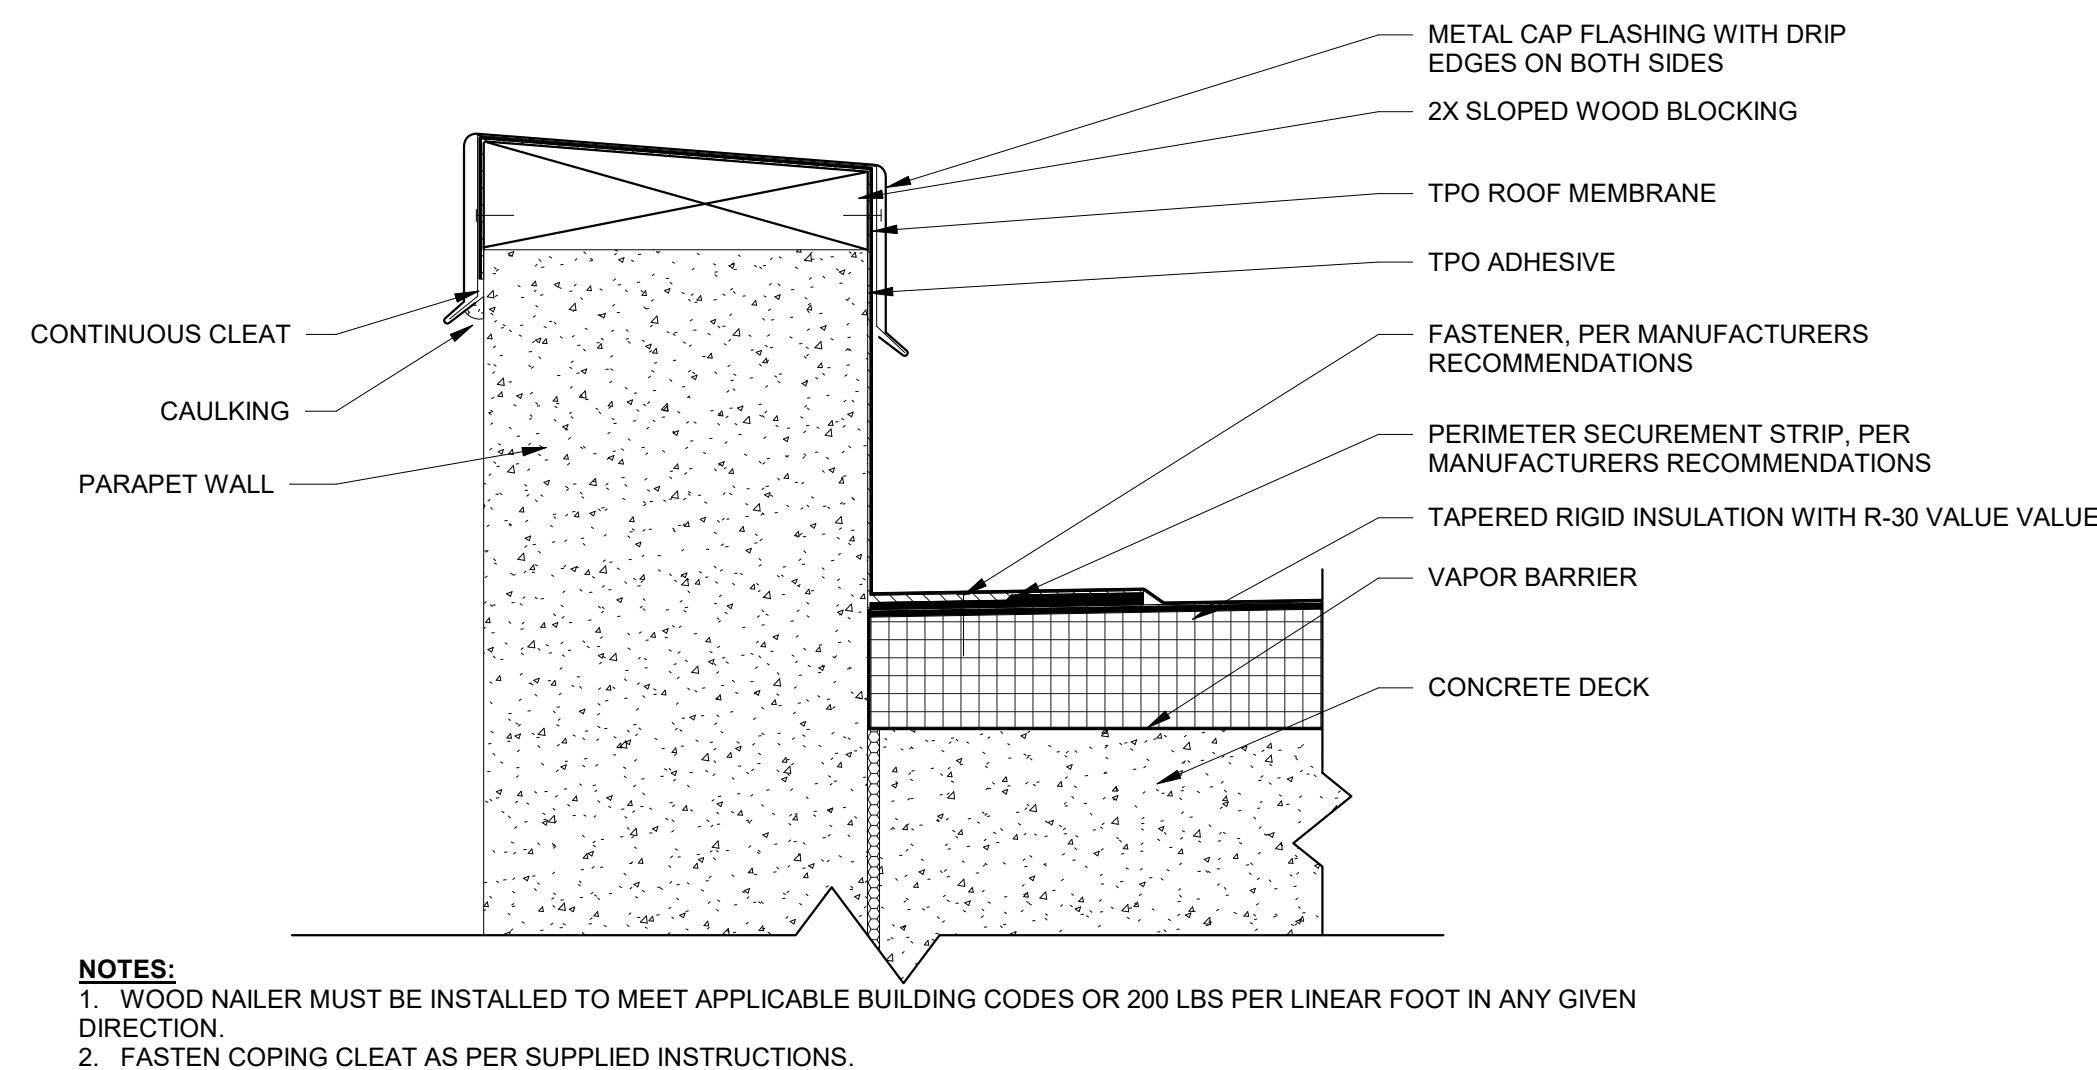


C1 PARAPET CAP DETAIL

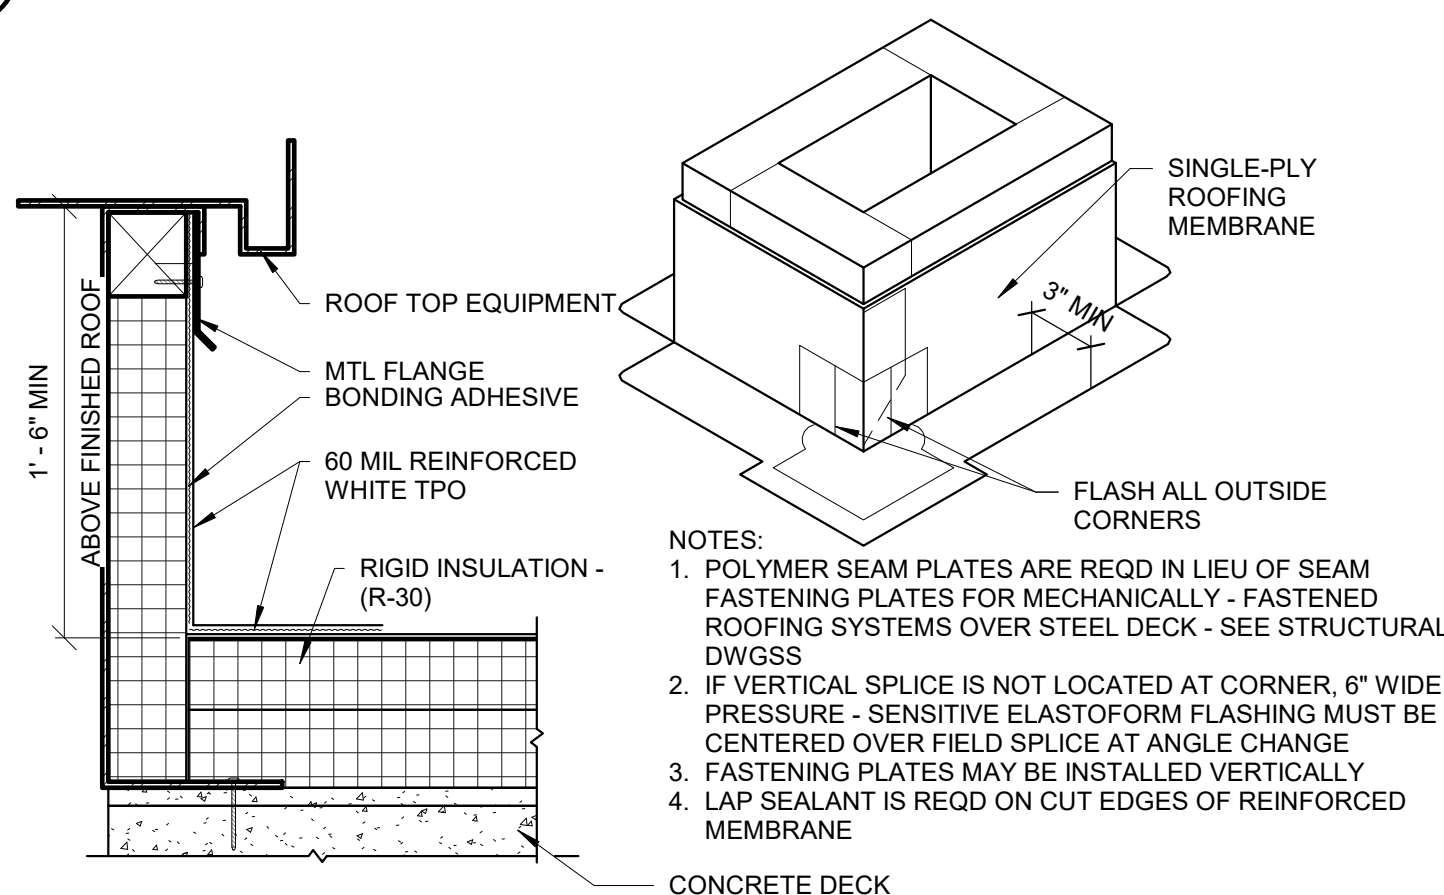


A1 CURB FLASHING

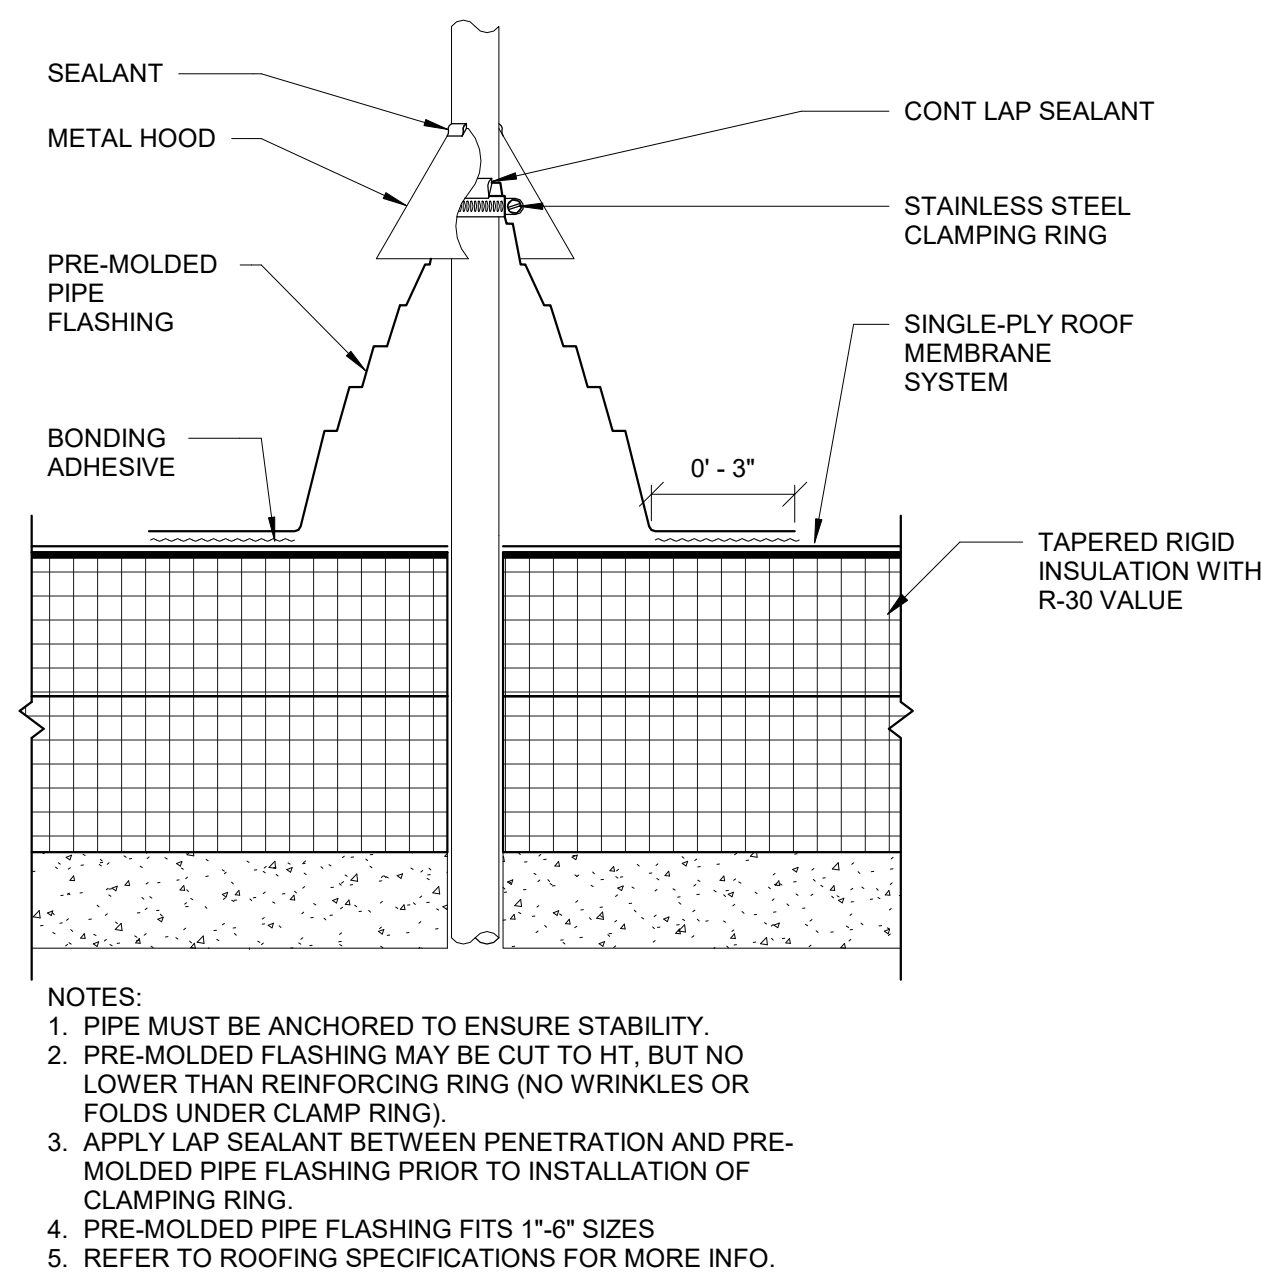


E5 PRE-MOLDED PIPE BOOT - TPO
3" = 1'-0"

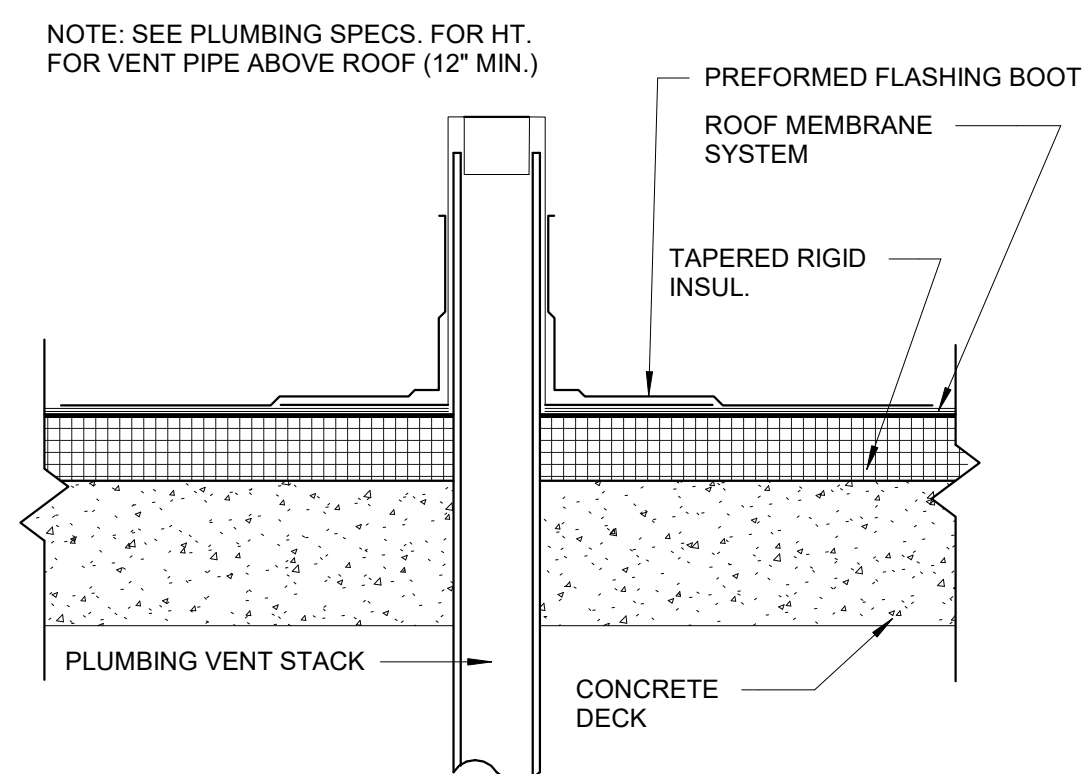


C5 FLASHING AT ROOF PENETRATION

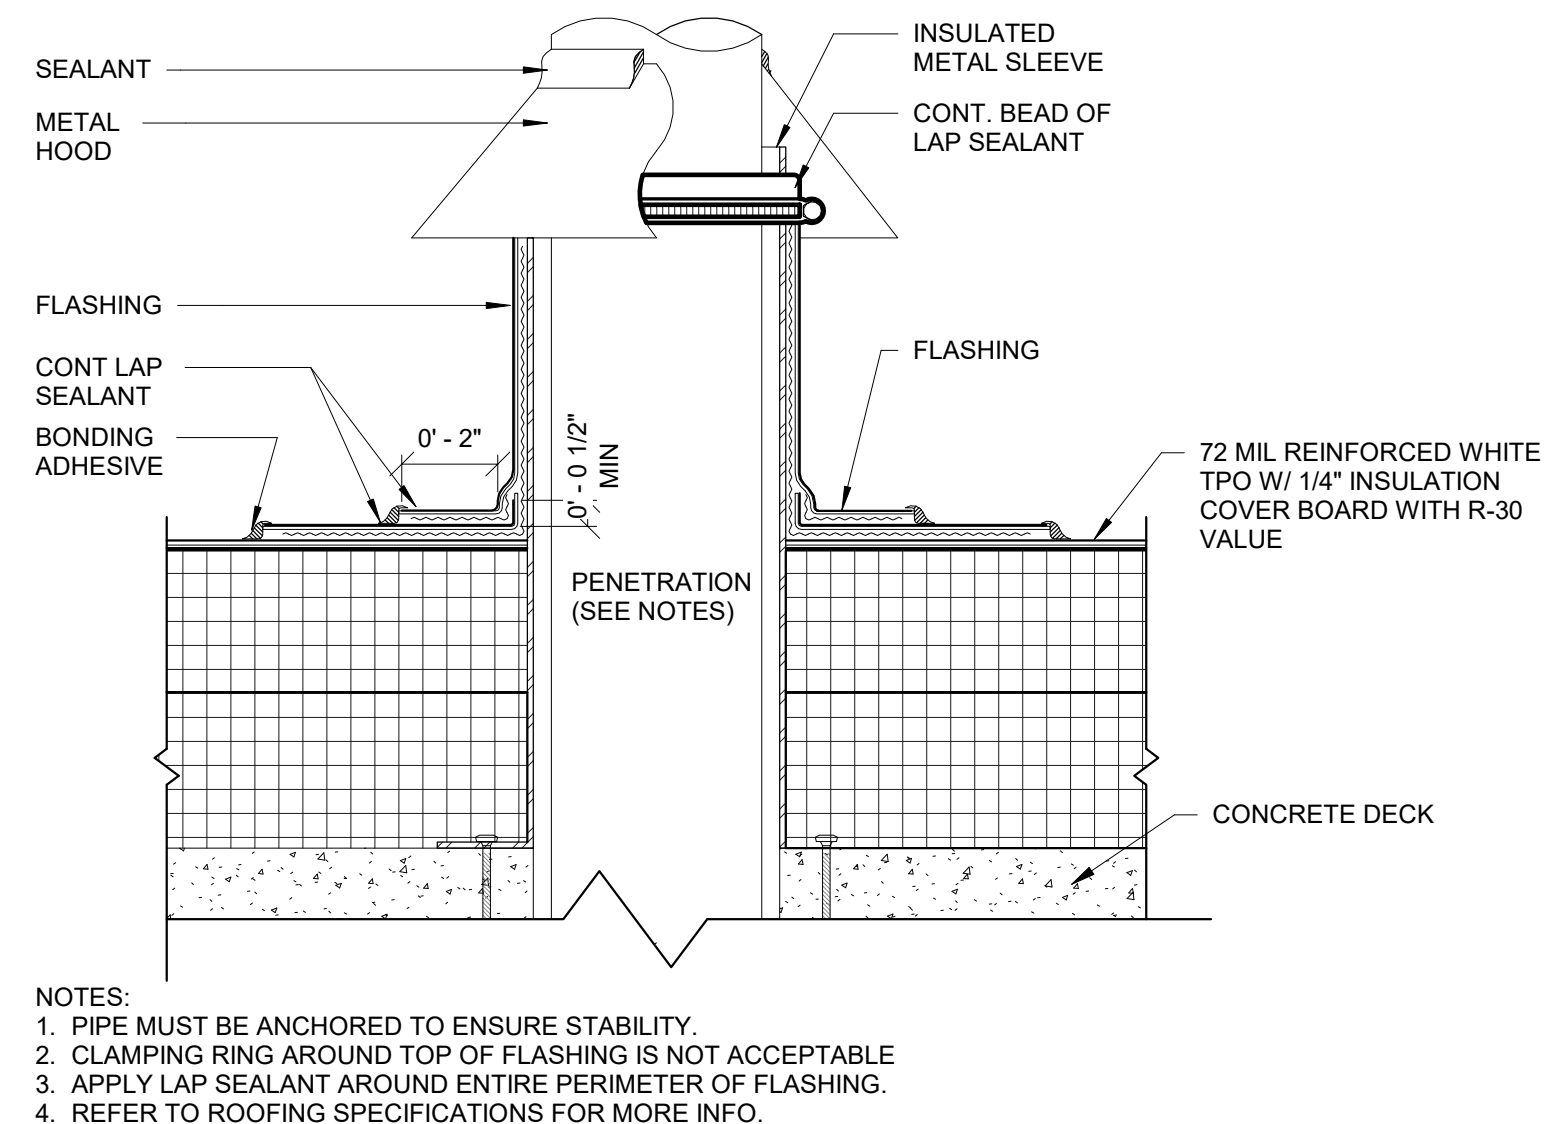

E8 PENETRATION FLASHING

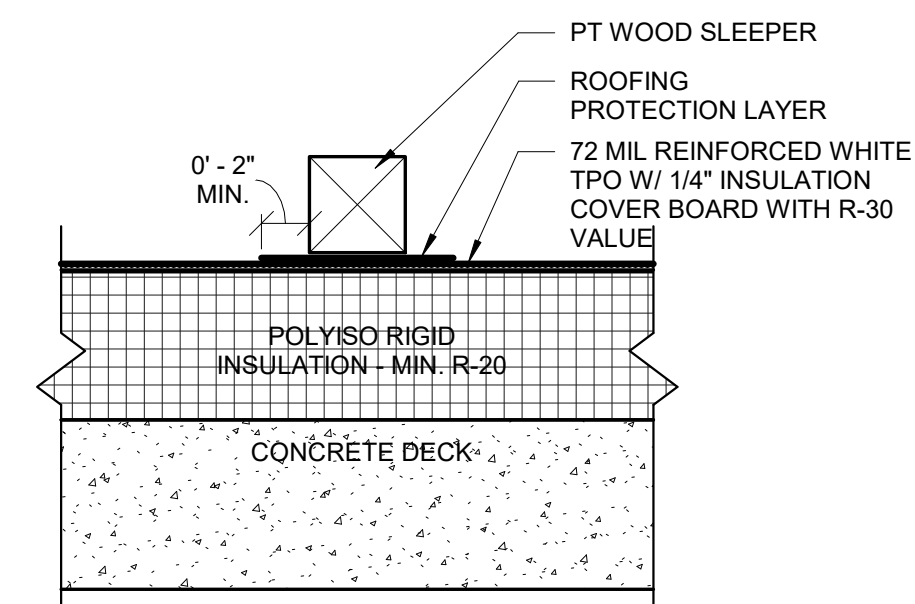

C8 WOOD SLEEPER/PIPE SUPPORT

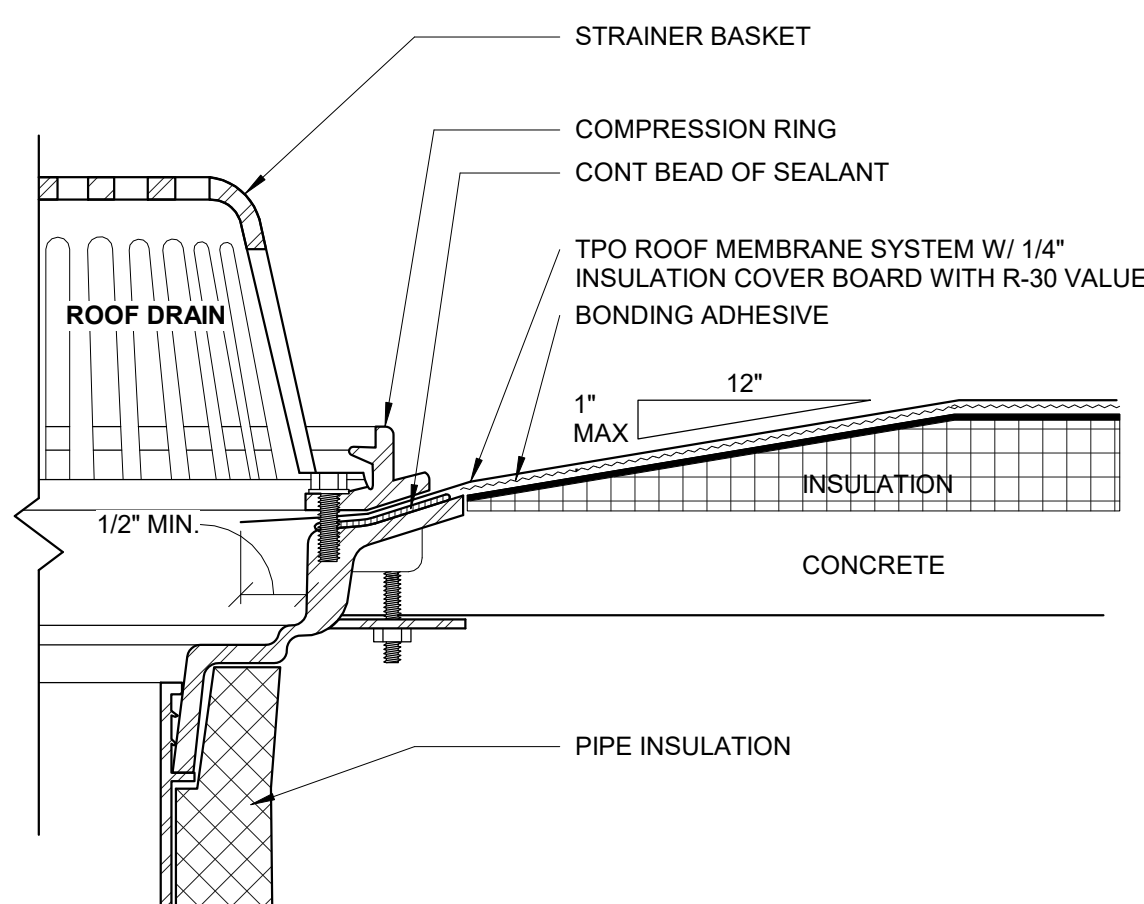

A5 ROOF DRAIN DETAILS

[illegible]

US ARMY CORPS OF ENGINEERS ST. LOUIS DISTRICT ST. LOUIS, MISSOURI 63103	DESIGNED BY:	MY	ISSUE DATE:	MAY 2021
	DRAWN BY:	SA	SOLUTION NO.:	50100001
	CHECKED BY:	SA	THEMATIC NO.:	50100001
	FA	CONTRACT NO.:		
	SUBMITTED BY:			
	SCALE:			
	SIZE:			
	ANSI/D			

MEL PRICE LOCKS AND DAM
MAIN LOCK OVERLOOK ALTERATIONS
ALTON, ILLINOIS
MISSISSIPPI RIVER
DETAILS - ROOF

DETAILS - ROOF

SHEET ID

AR301